
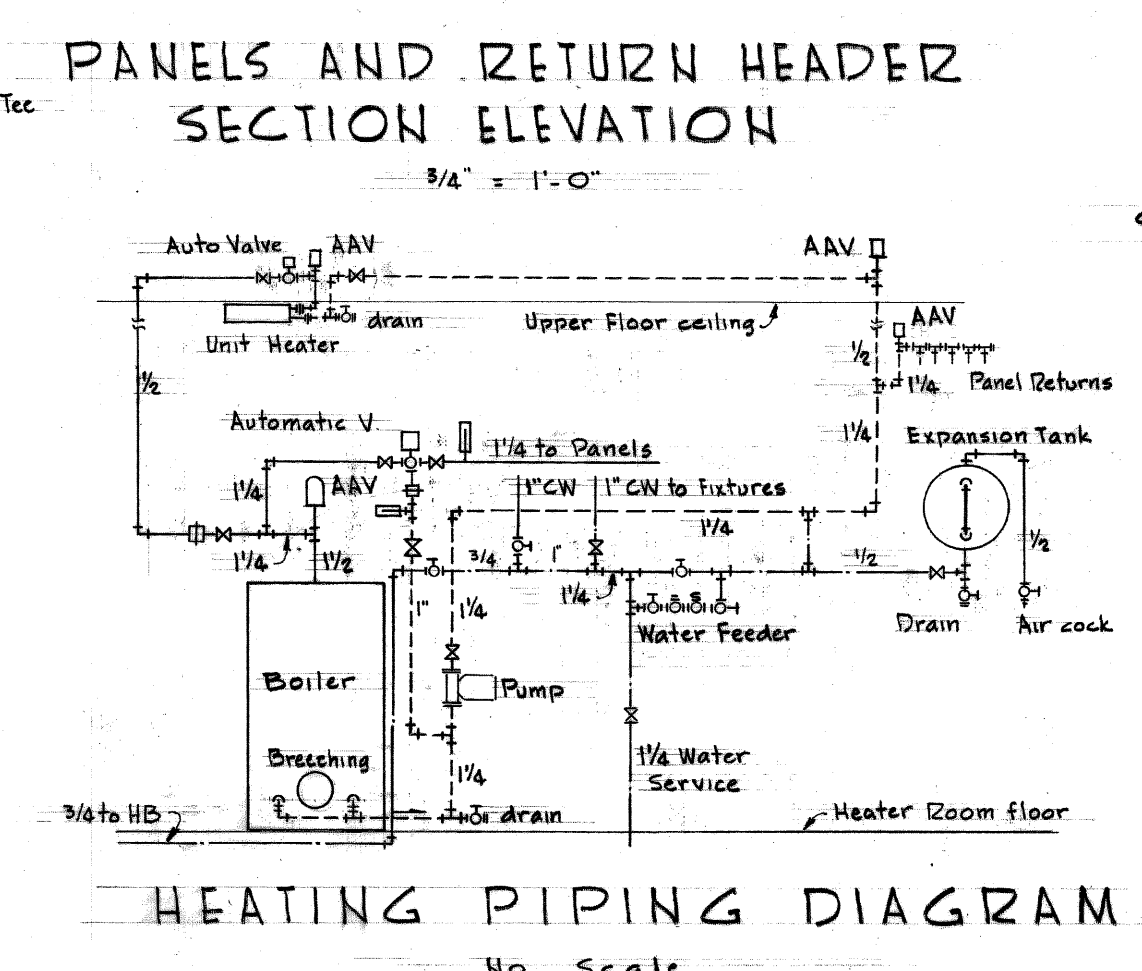
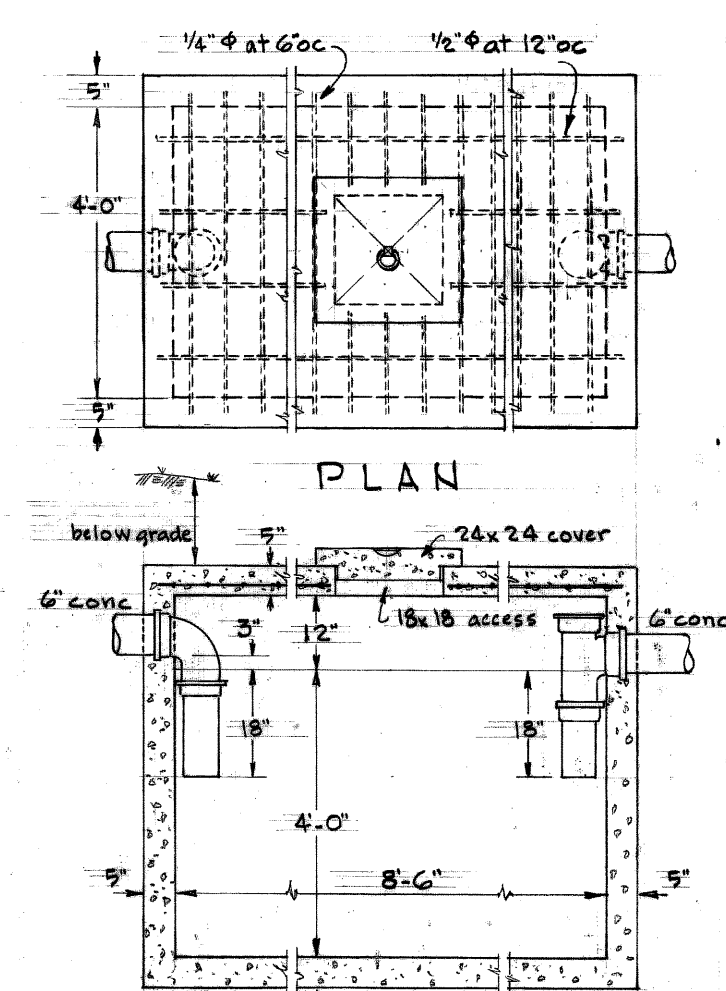
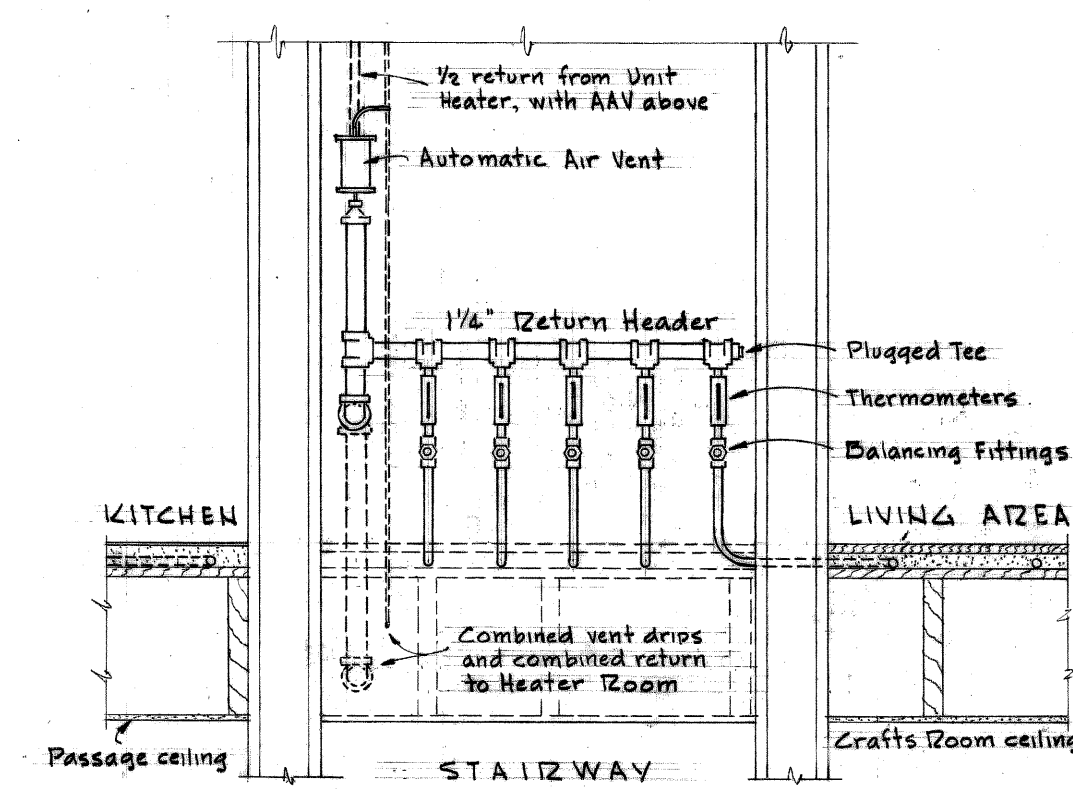
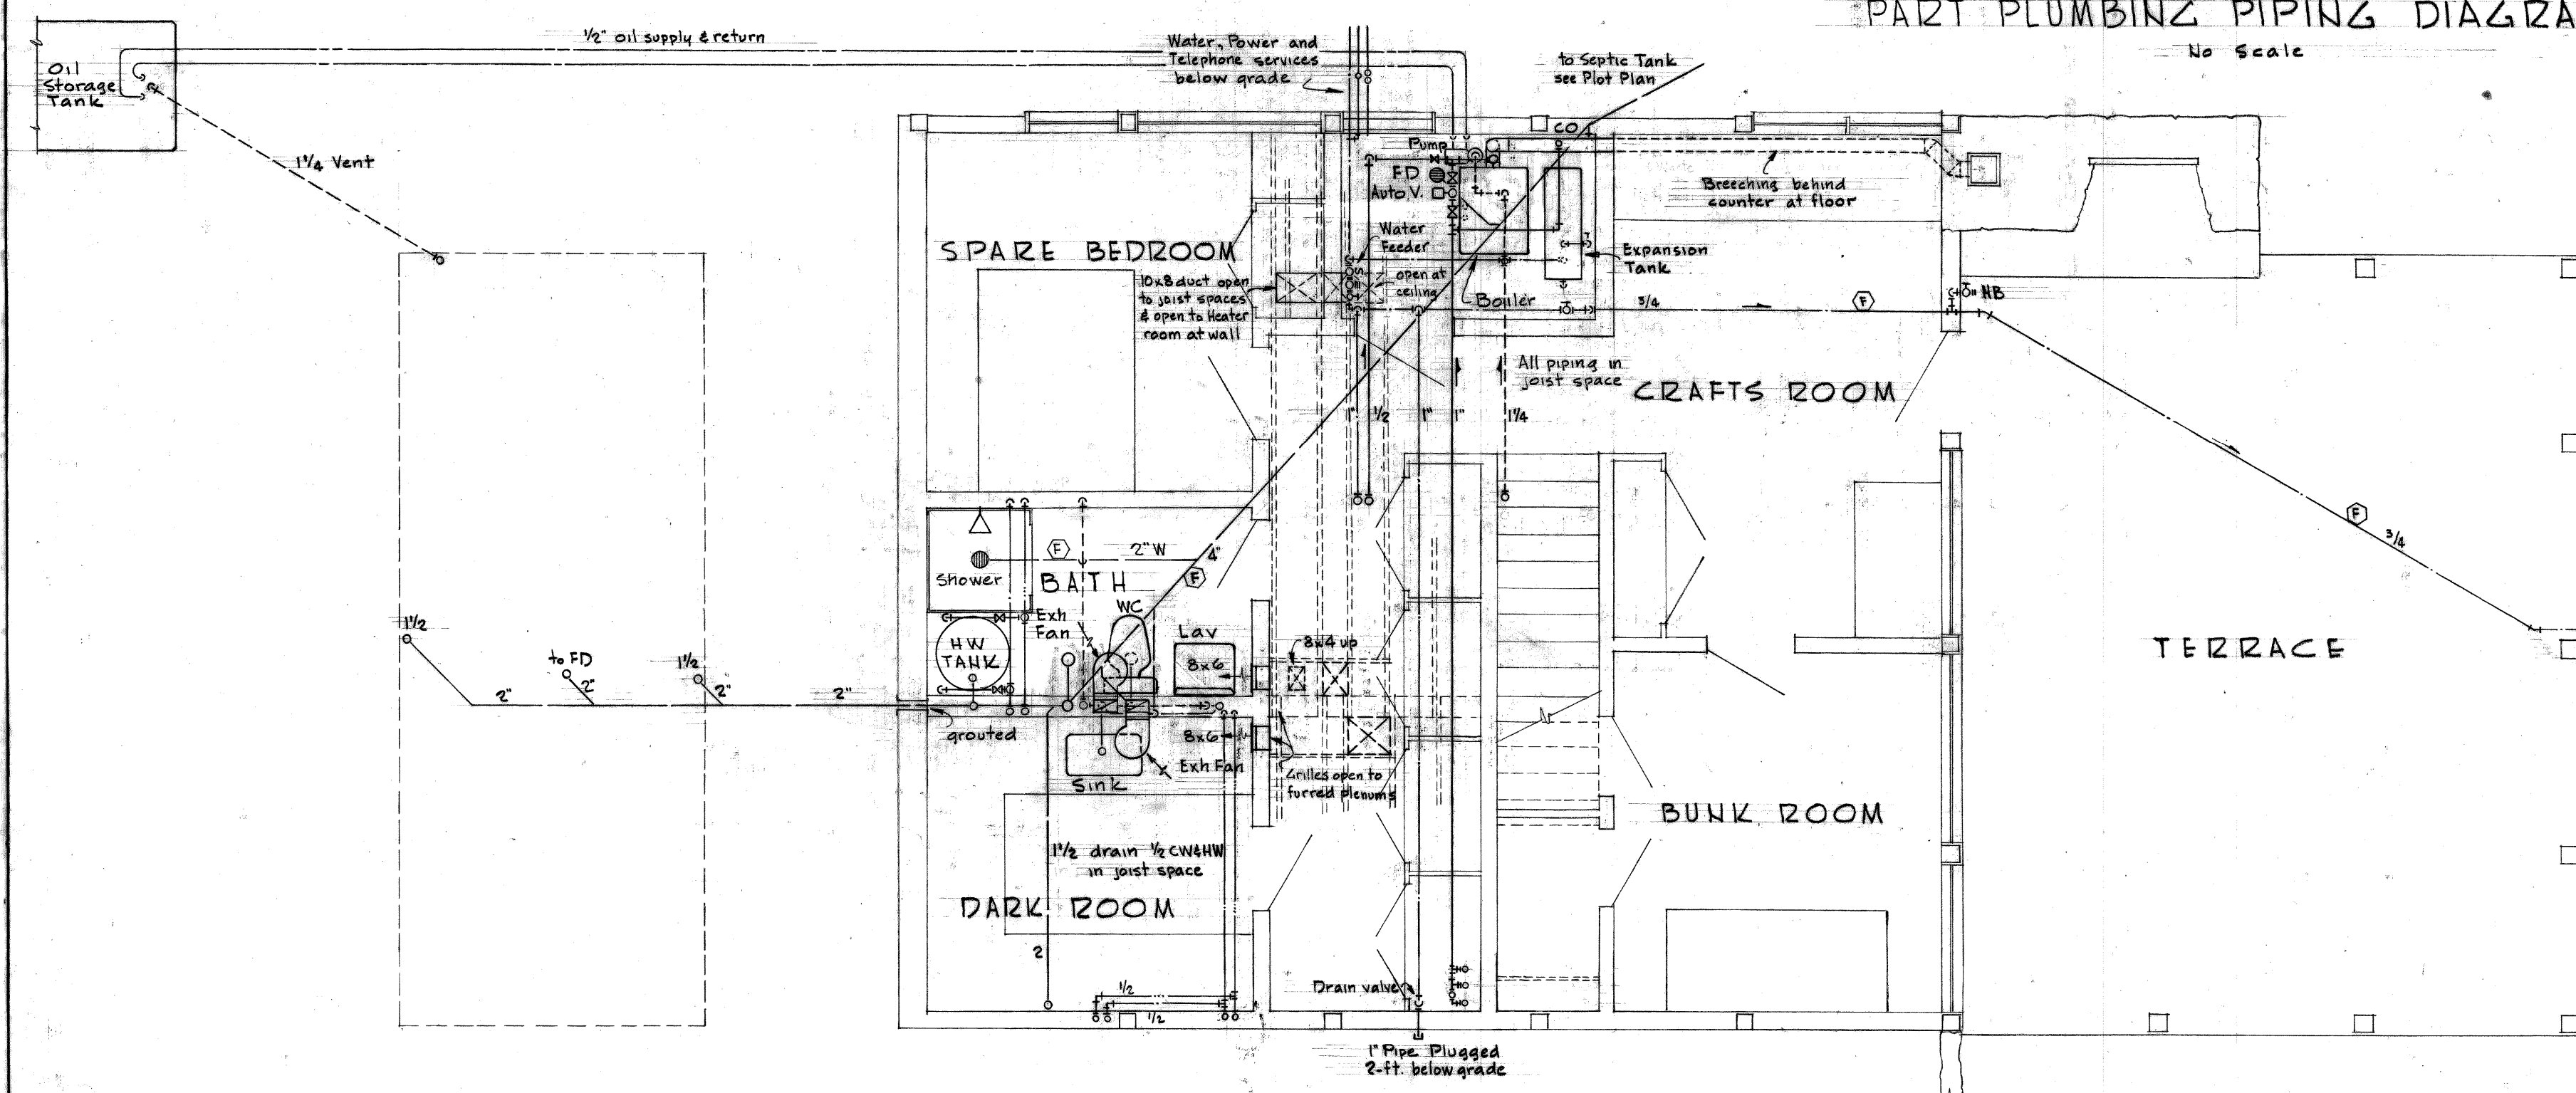
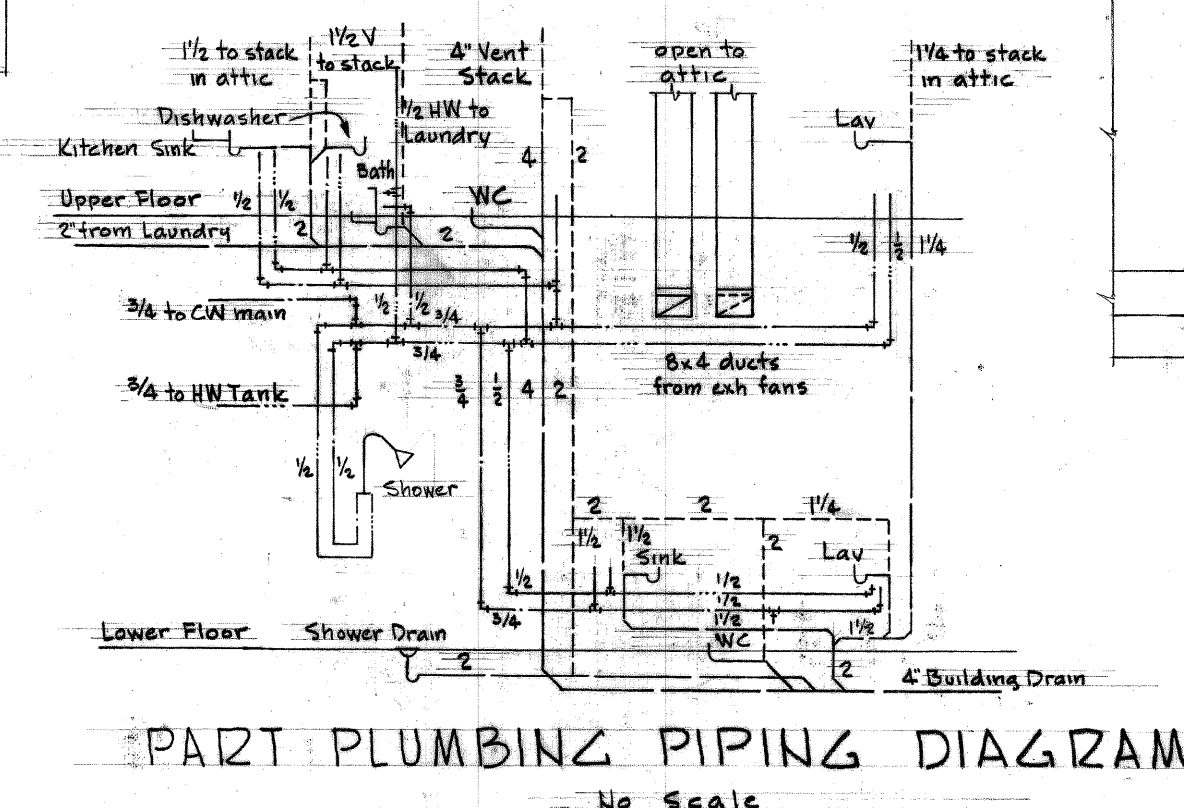
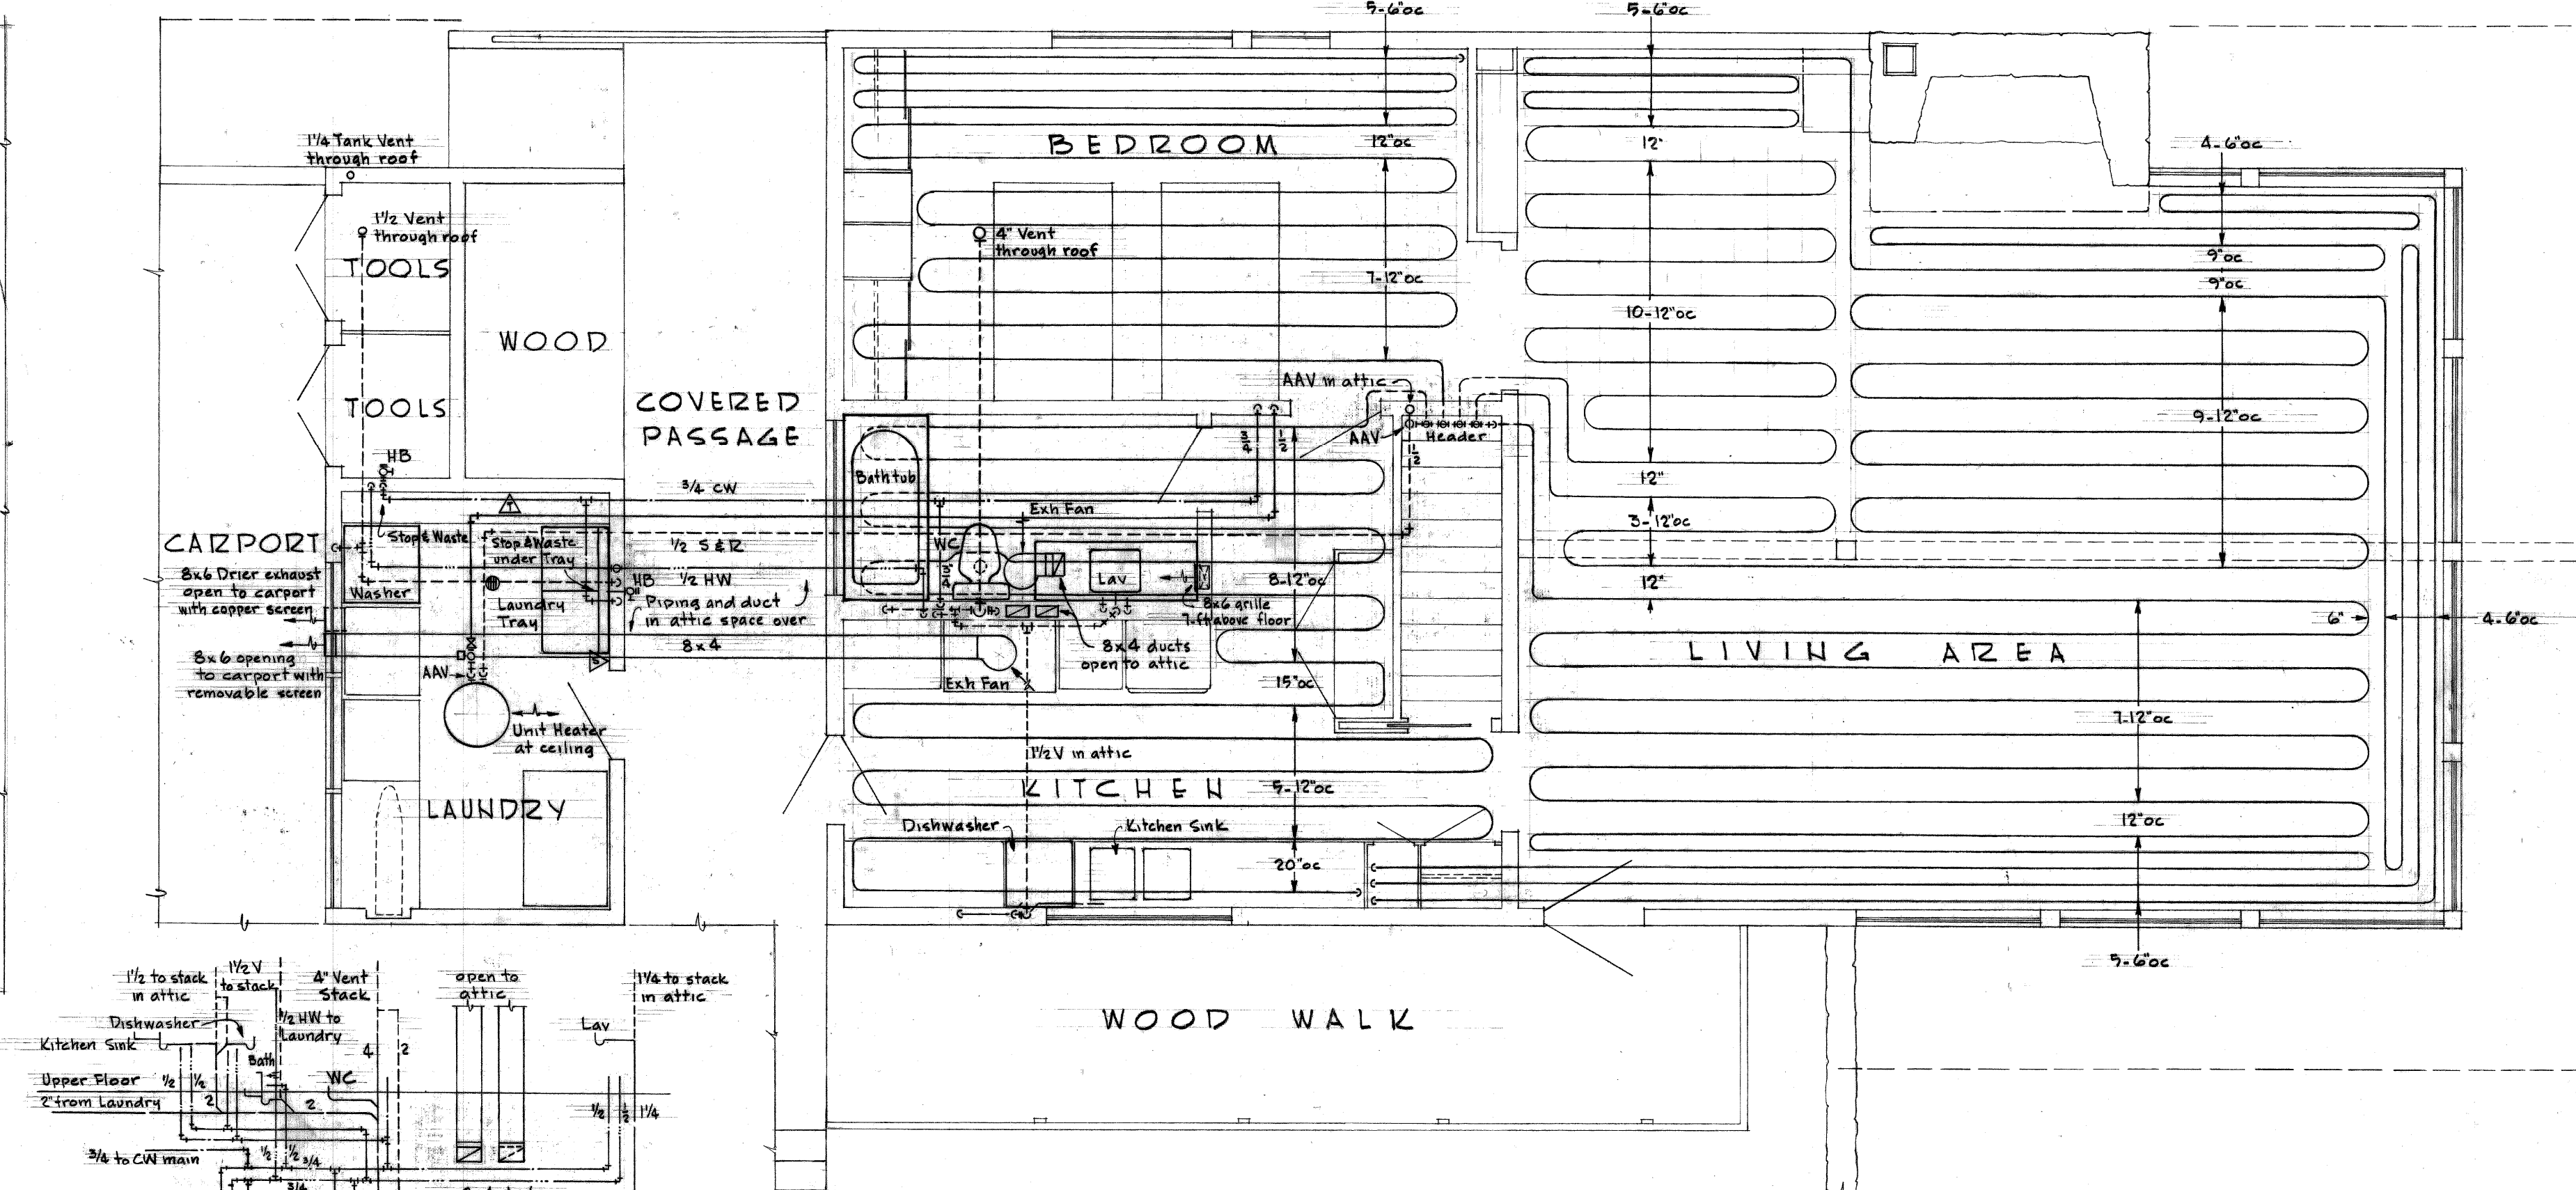


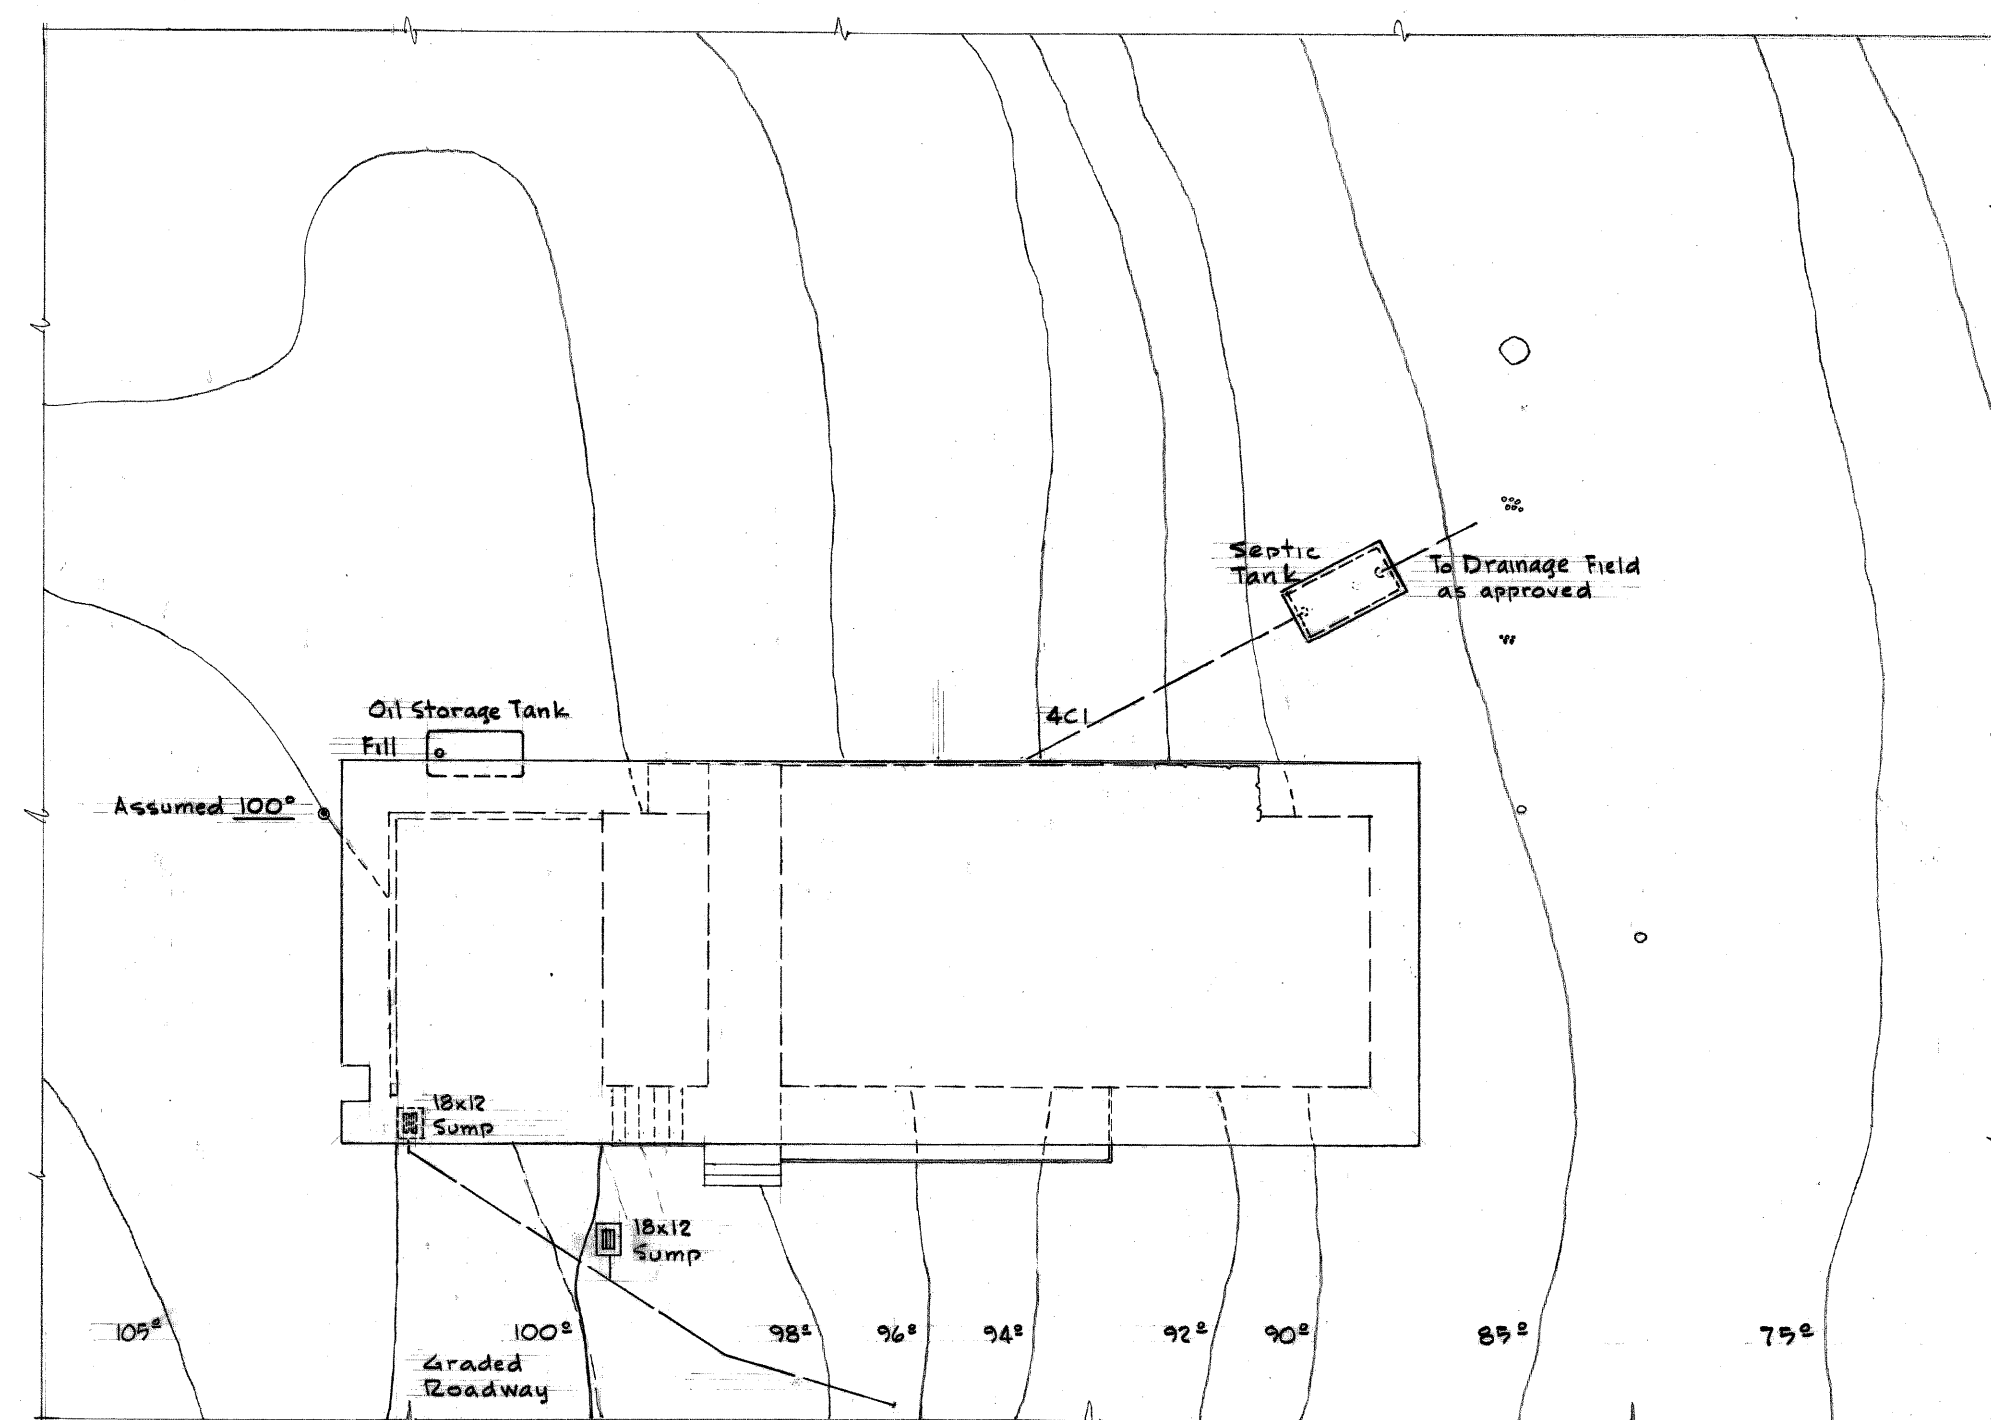

- SYMBOLS.

- | | | |
|--|------------|----------------------------------|
| | S | Heating supply piping |
| | R | Heating return piping |
| | | Delta valve |
| | | Automatic valve |
| | | Gate valve |
| | | Balancing Fitting |
| | | Union |
| | | Thermometer |
| | | Hose end drain valve |
| | AAV | Automatic air vent |
| | | Location for thermostat & switch |
| | | Duct section supply & exhaust |
| | | Wall supply grille |
| | CW | Cold water piping |
| | HW | Hot water piping |
| | | Waste, soil and drainage piping |
| | V | Vent piping |
| | | Piping below floor |
| | CO | Cleanout |
| | | Pressure reducing valve |
| | | Relief valve |
| | FD | Floor drain |
| | | Floor drain |

MECHANICAL PLANS & DETAILS			
MOUNTAIN HOUSE FOR MR & MRS J DONALD KROEGER MILWAUKIE HEIGHTS, OREGON			
THE OFFICE OF PIETRO BELLUSCHI - ARCHITECT 1040 S. W. JEFFERSON STREET - PORTLAND 1, OREGON			
SCALE AS SHOWN	REVISIONS: General and Septic Tank size	DATE Oct. 2, 1950	DRAWING NO. M-1
JOB NO. 216	11-7-50		