
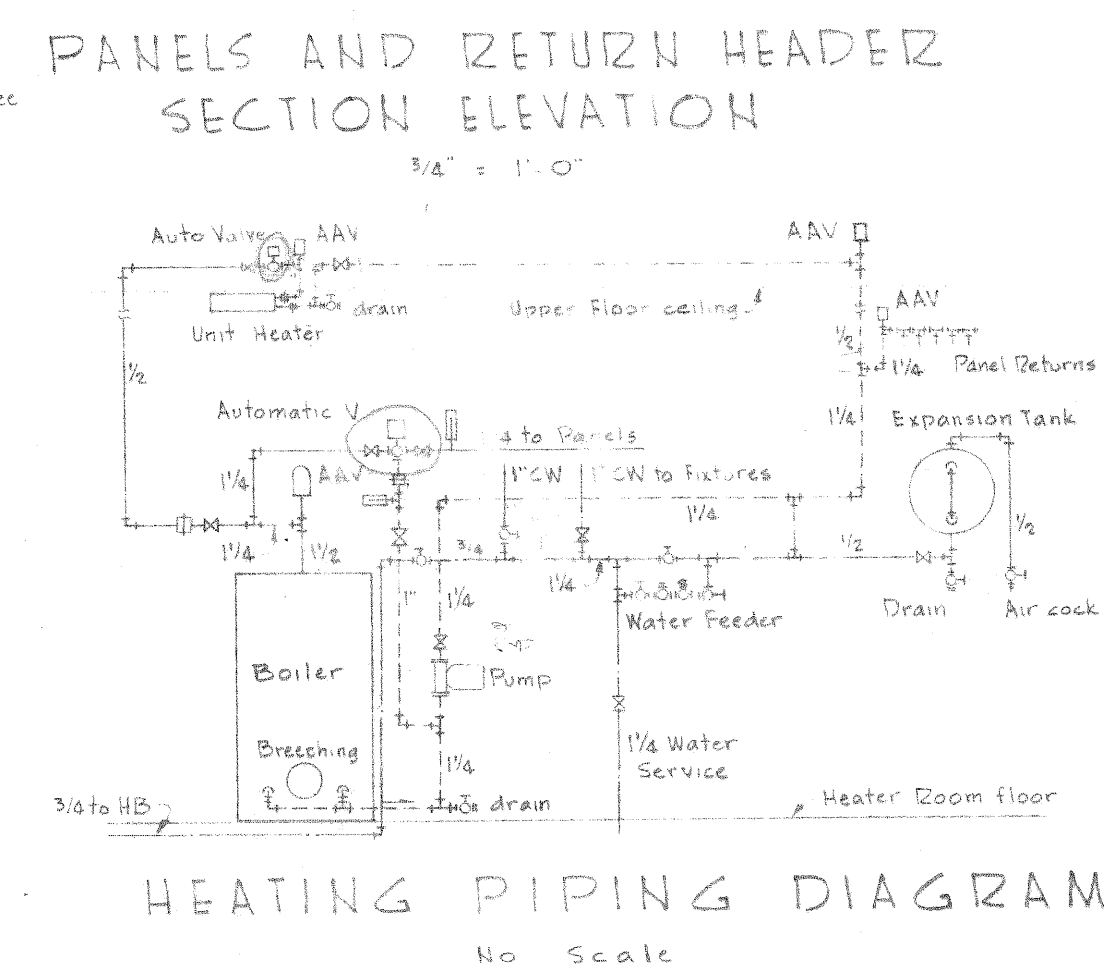
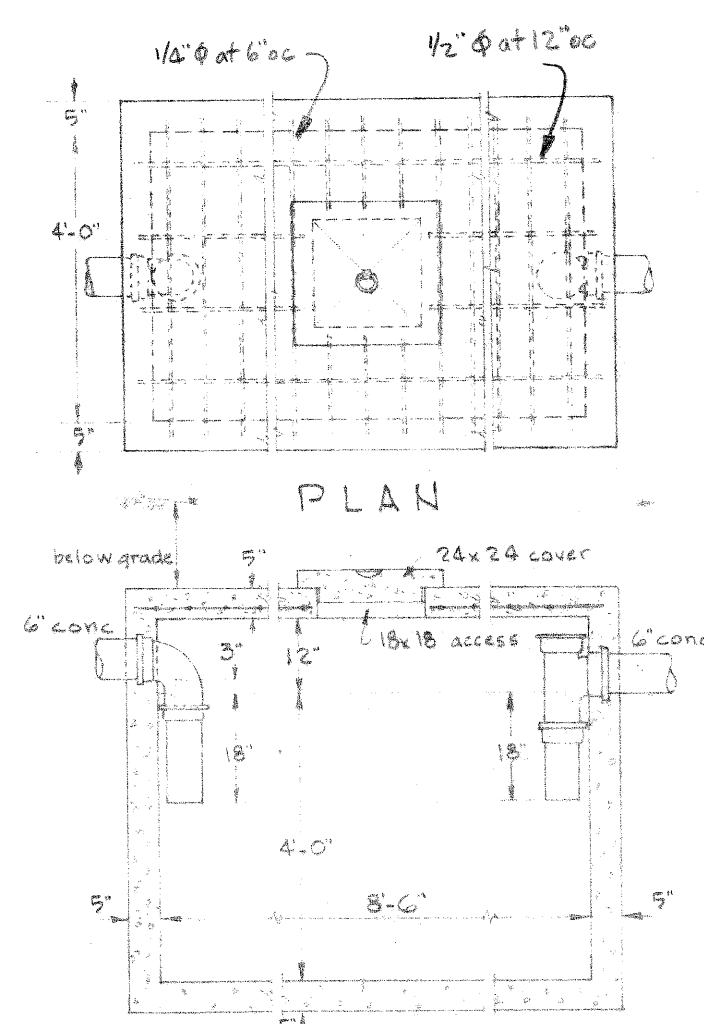
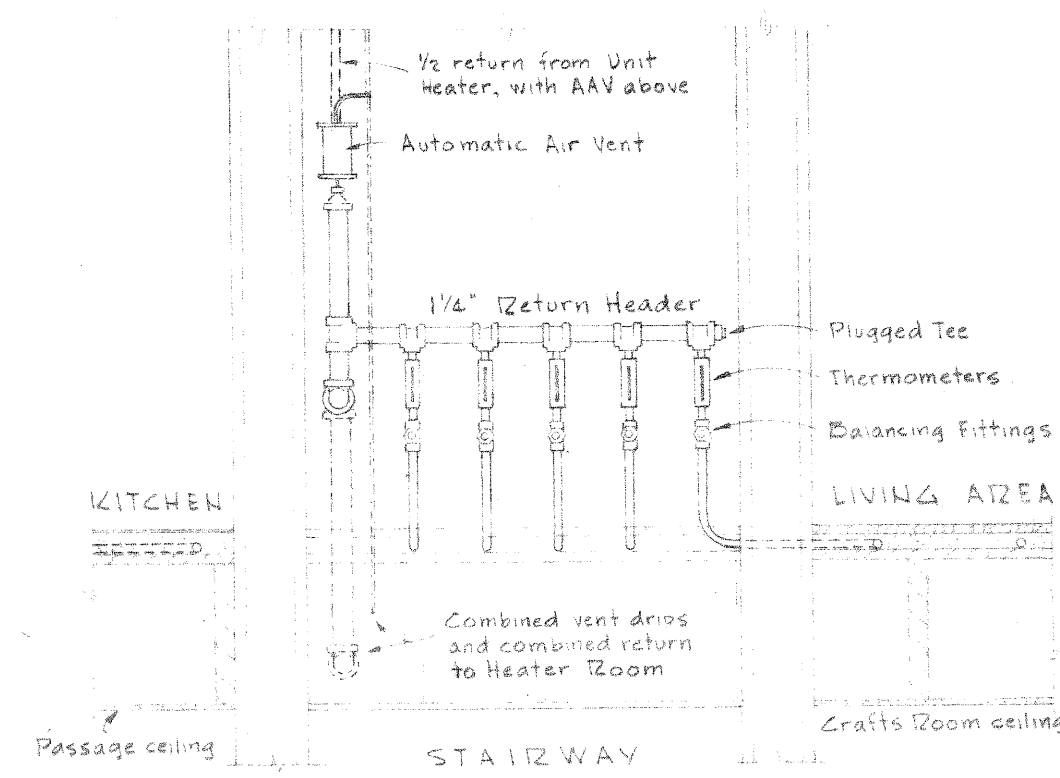
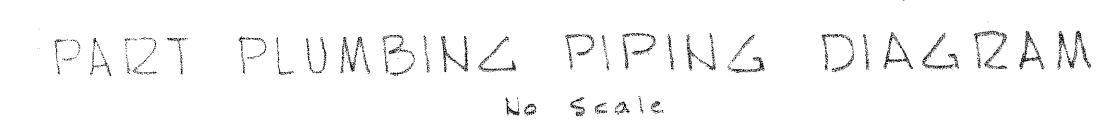
 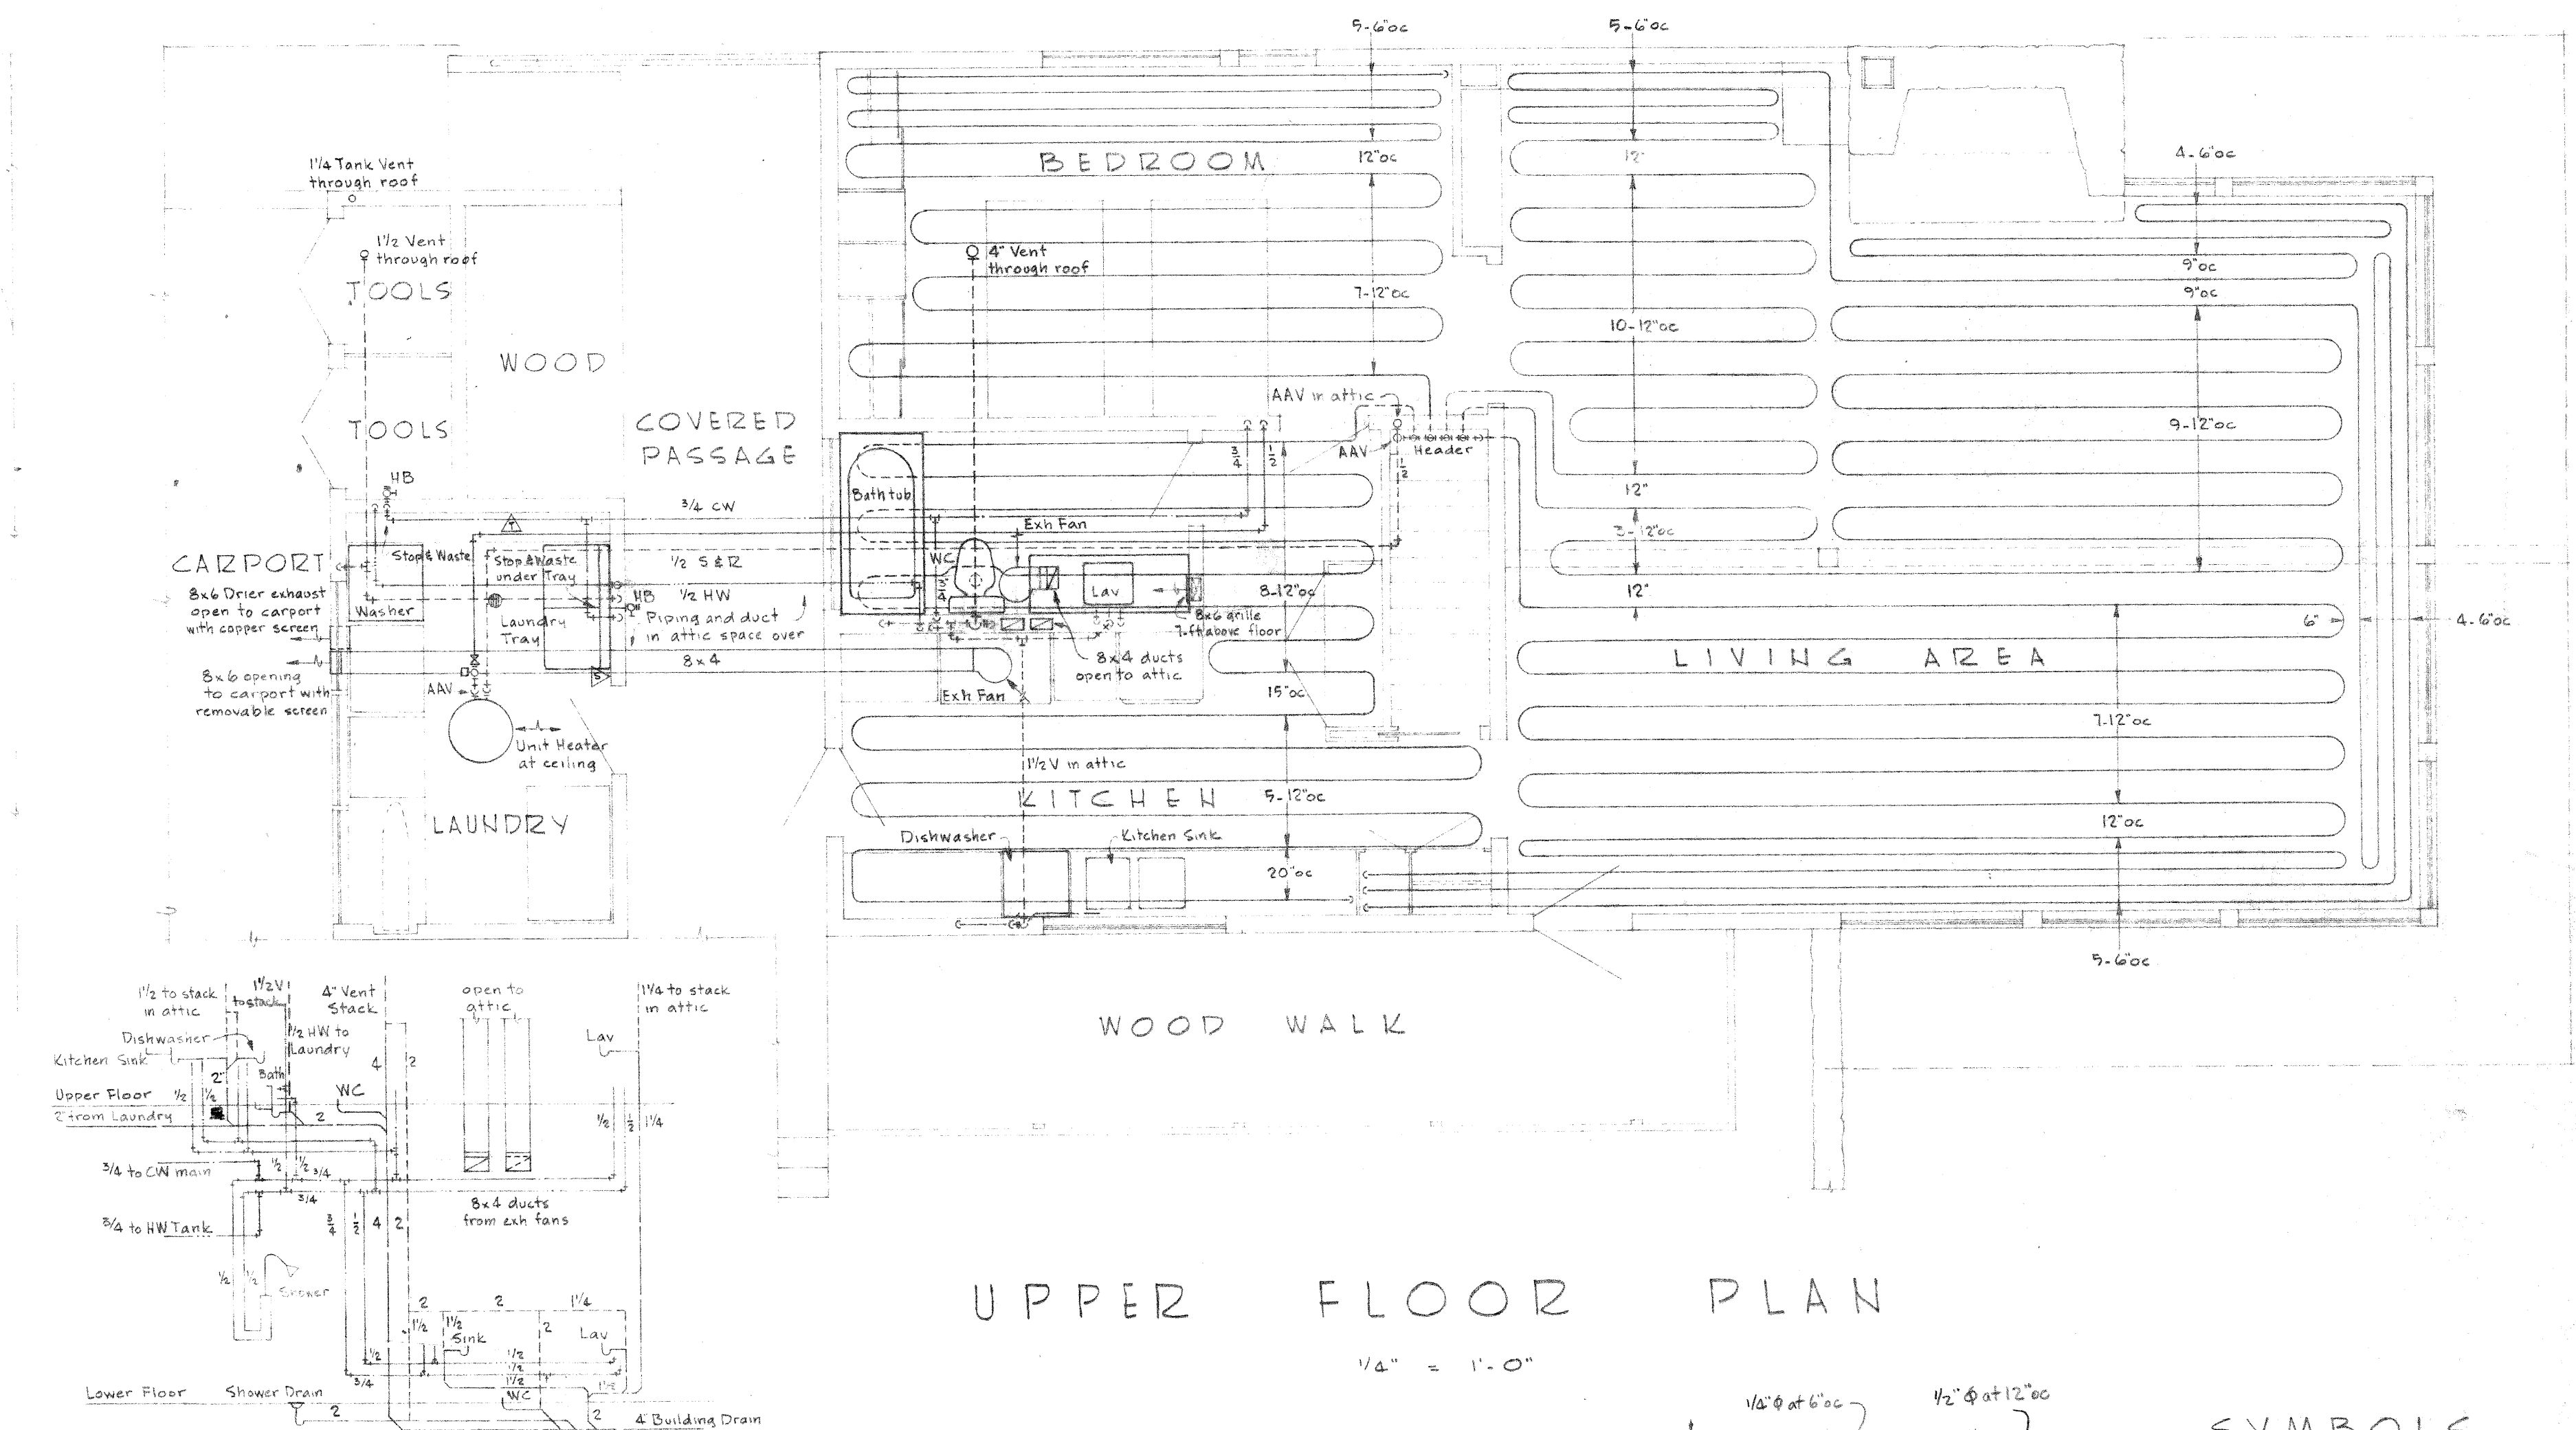
 




- # SYMBOLS.
- | | |
|---|----------------------------------|
|  | S Heating supply piping |
|  | R Heating return piping |
|  | Globe valve |
|  | Automatic valve |
|  | Gate valve |
|  | Balancing Fitting |
|  | Union |
|  | Thermometer |
|  | Hose and drain valve |
|  | AAV Automatic air vent |
|  | Location for thermostat & switch |
|  | Duct section supply & exhaust |
|  | Wall supply grille |
|  | CW Cold water piping |
|  | HW Hot water piping |
|  | Waste, soil and drainage piping |
|  | V Vent piping |
|  | Piping below floor |
|  | CO Cleanout |
|  | Pressure reducing valve |
|  | Relief valve |
|  | FD Floor drain |
|  | HB Hose bibb |

- ## GENERAL NOTES.
1. Boiler burner unit, pump, water heater, exhaust fans, temperature control equipment, and all plumbing fixtures except floor drain are provided by others.
 2. Temperature control equipment installed by others. Installation of equipment shown including those listed above and making of final connections thereto are under the scope of this work.

MECHANICAL PLANS & DETAILS			
MOUNTAIN HOUSE FOR MR & MRS J DONALD KROEGER MILWAUKIE HEIGHTS, OREGON			
THE OFFICE OF PIETRO BELLUSCHI - ARCHITECT 8040 S. W. JEFFERSON STREET - PORTLAND 1, OREGON			
SCALE	REVISIONS:	DATE	
As SHOWN	General and Septic Tank - size	11-7-50	Oct. 2, 1950
ISS. NO.		DRAWING NO.	M-1
216			