
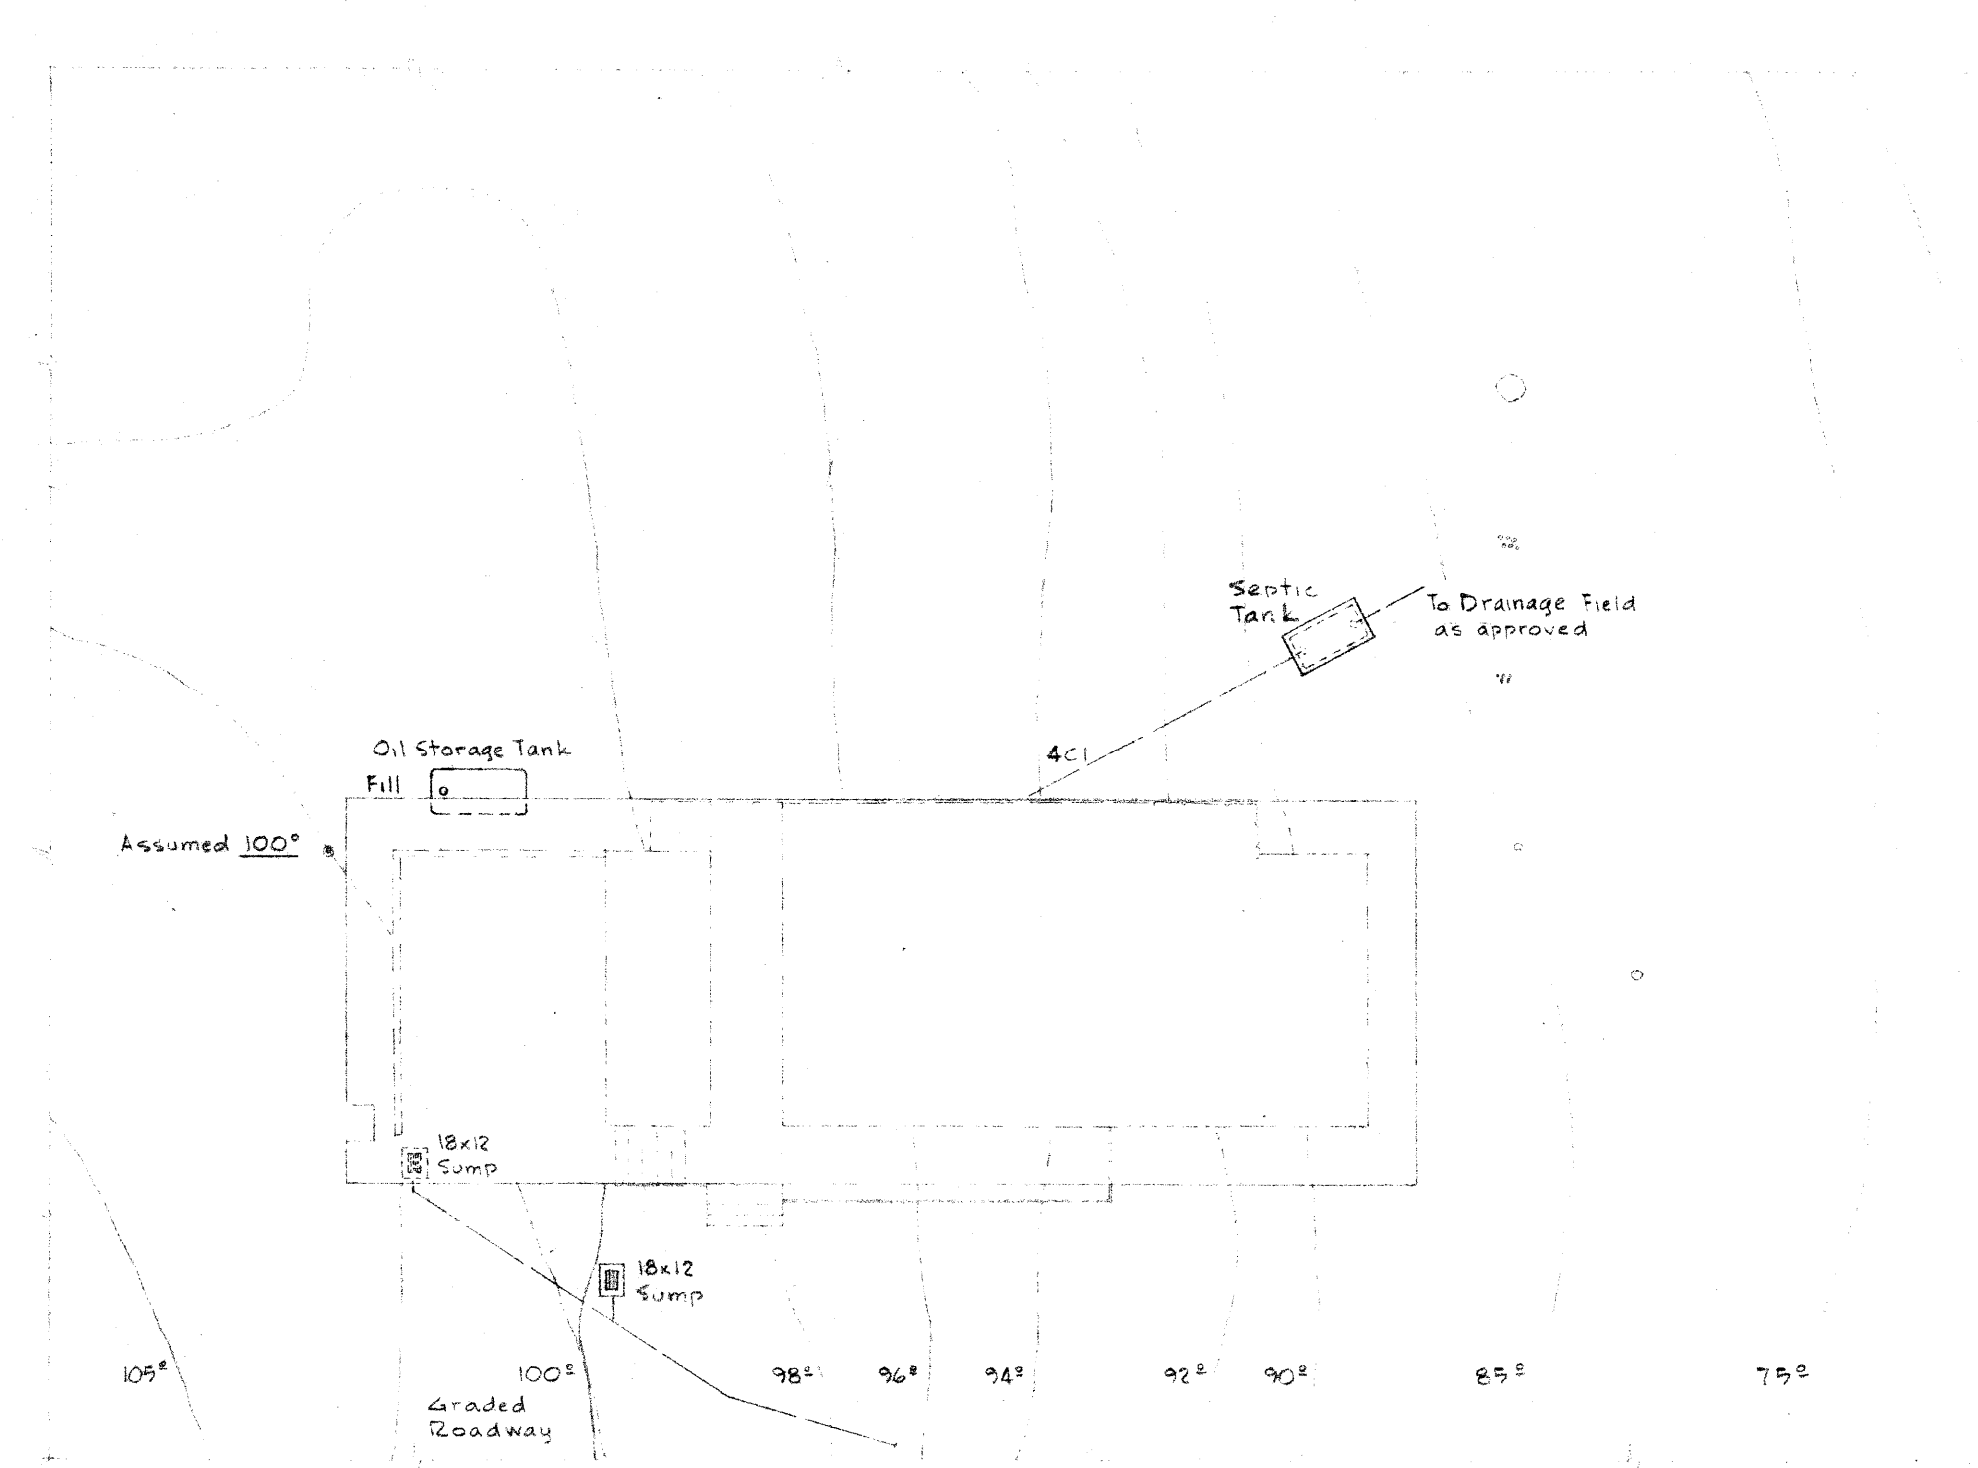
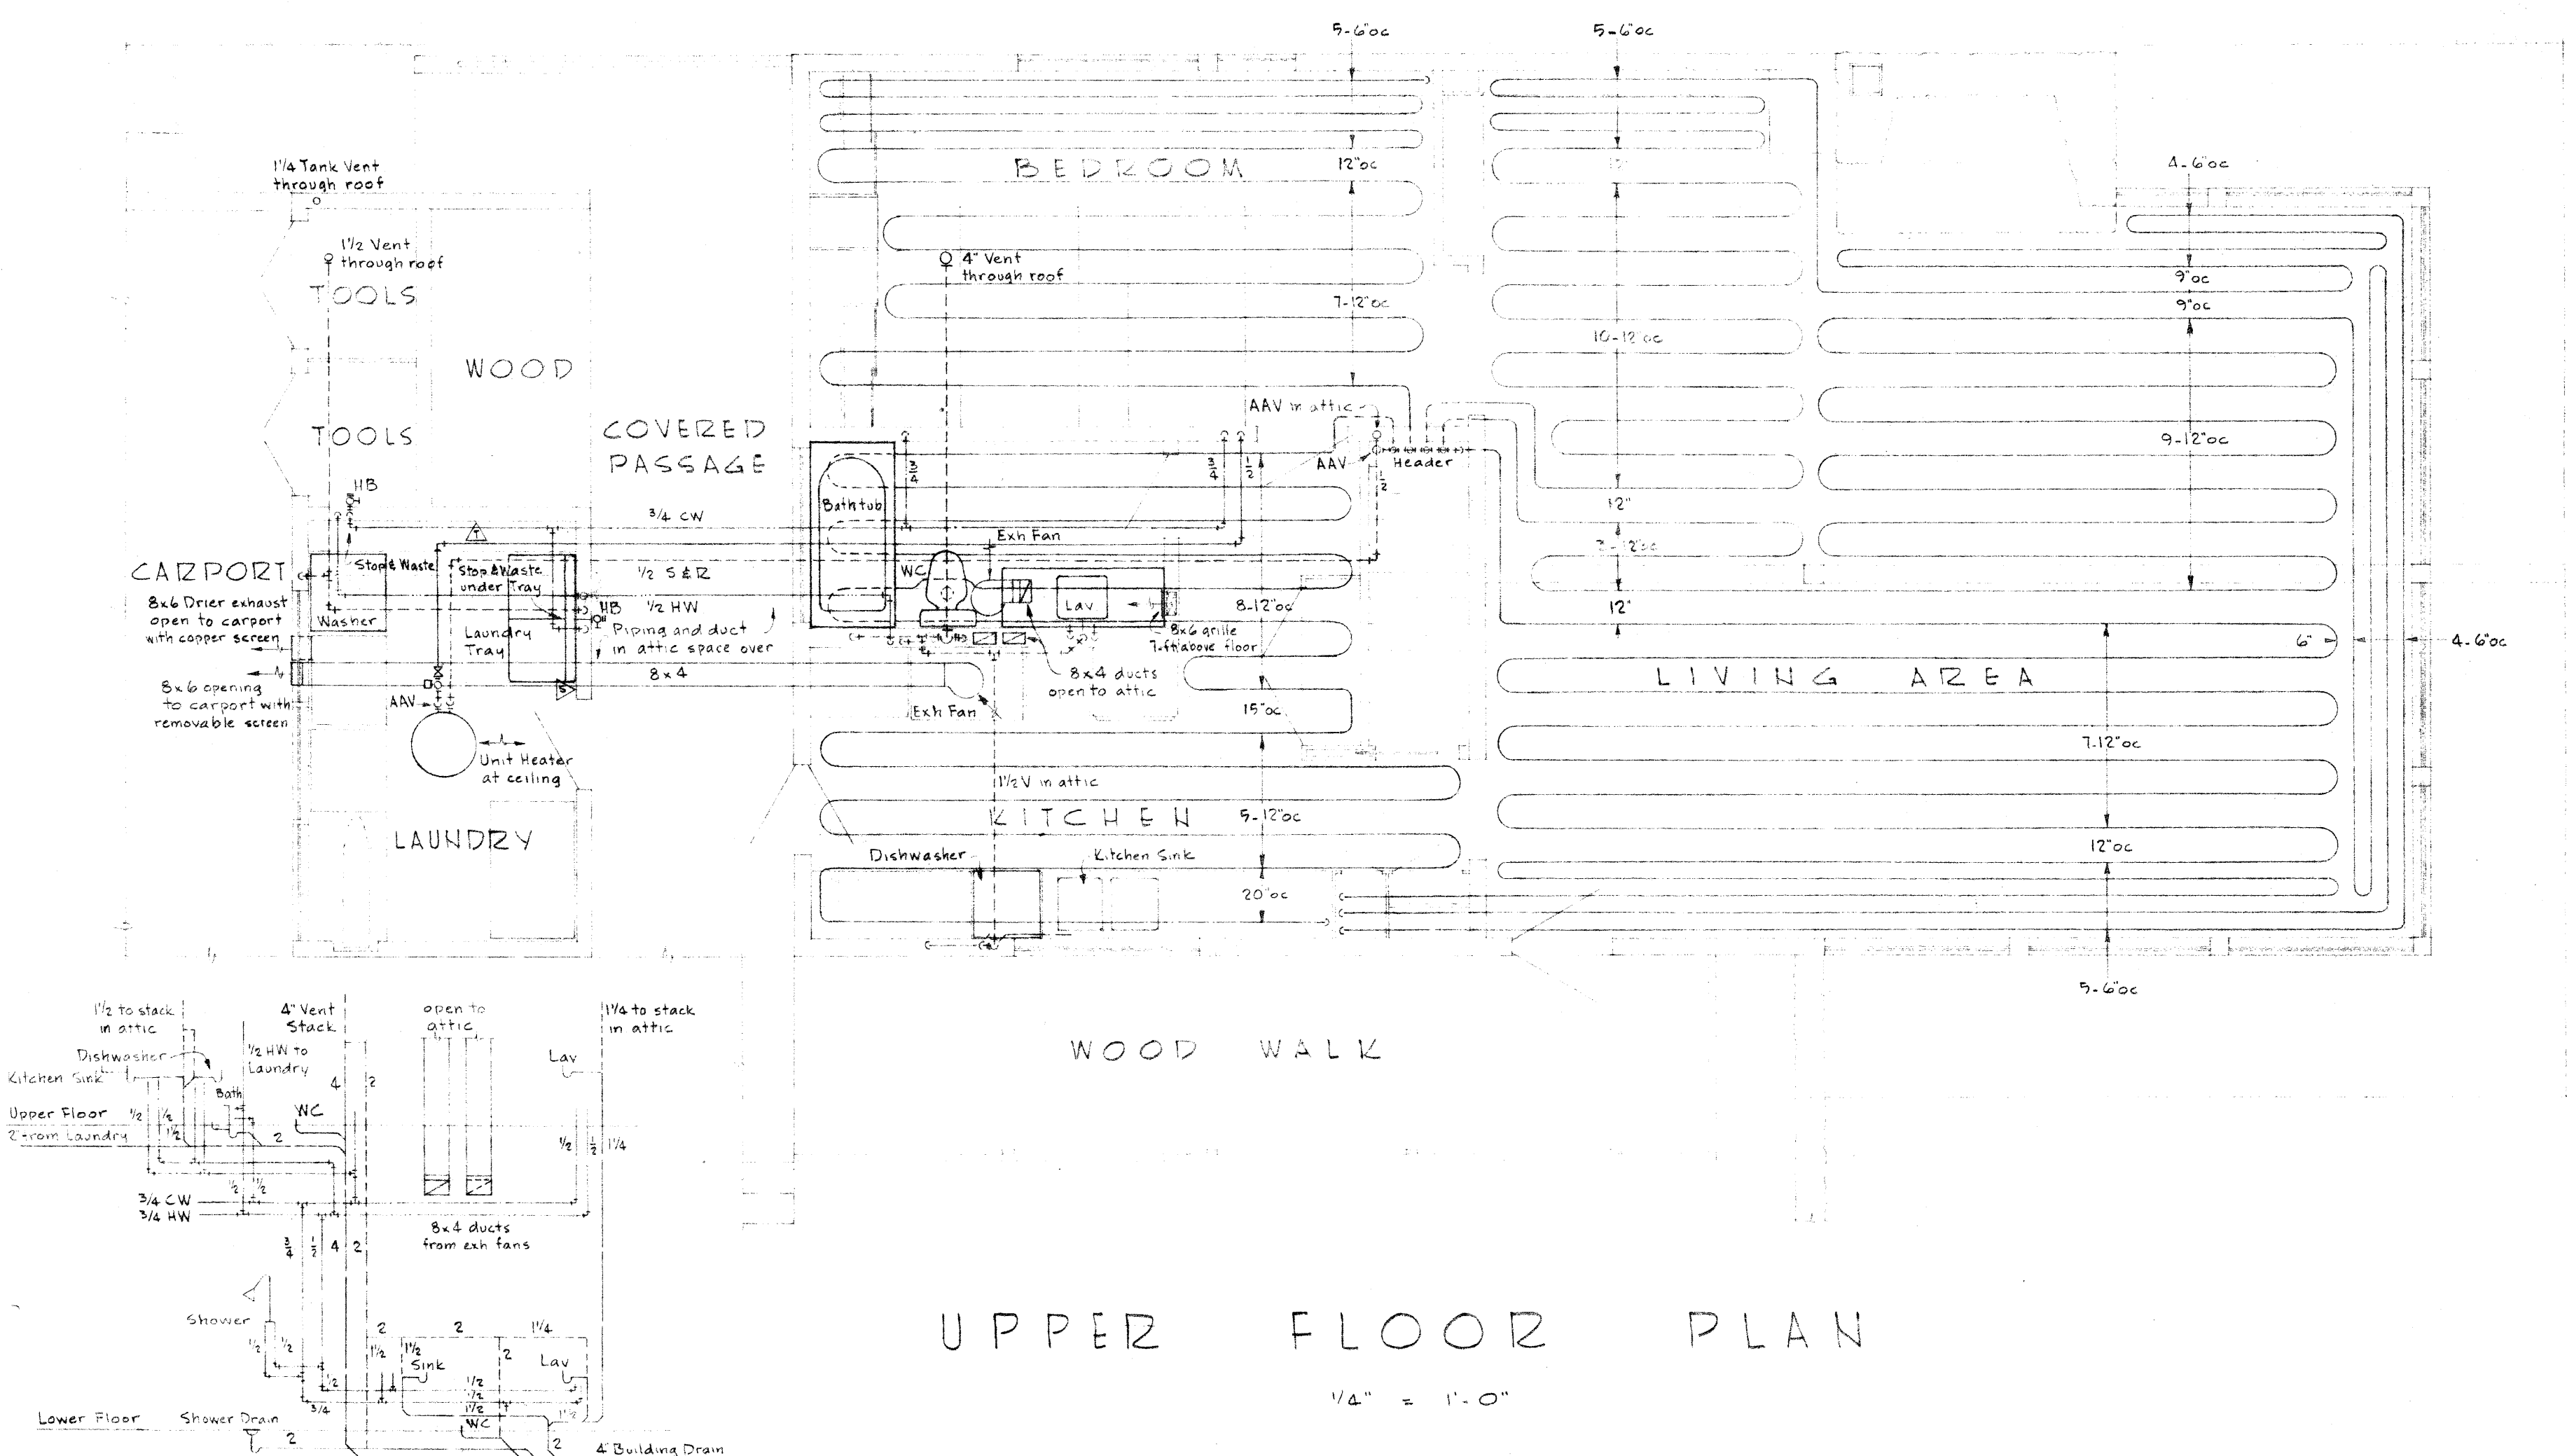


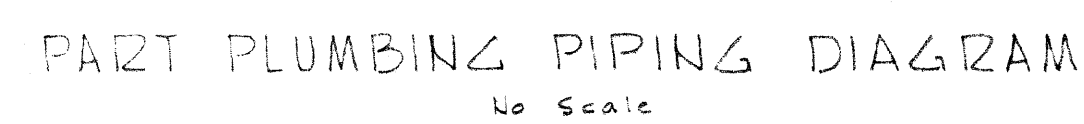


PART PLOT PLAN

$$1/16" = 1.0"$$


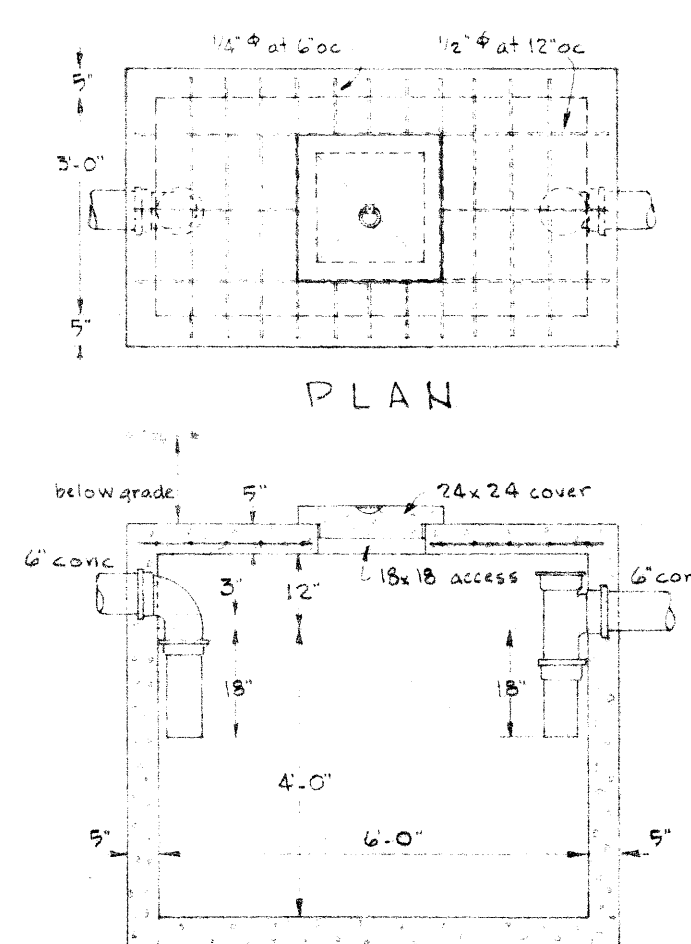
UPPER FLOOR PLAN

$$1/4" = 1'-0"$$


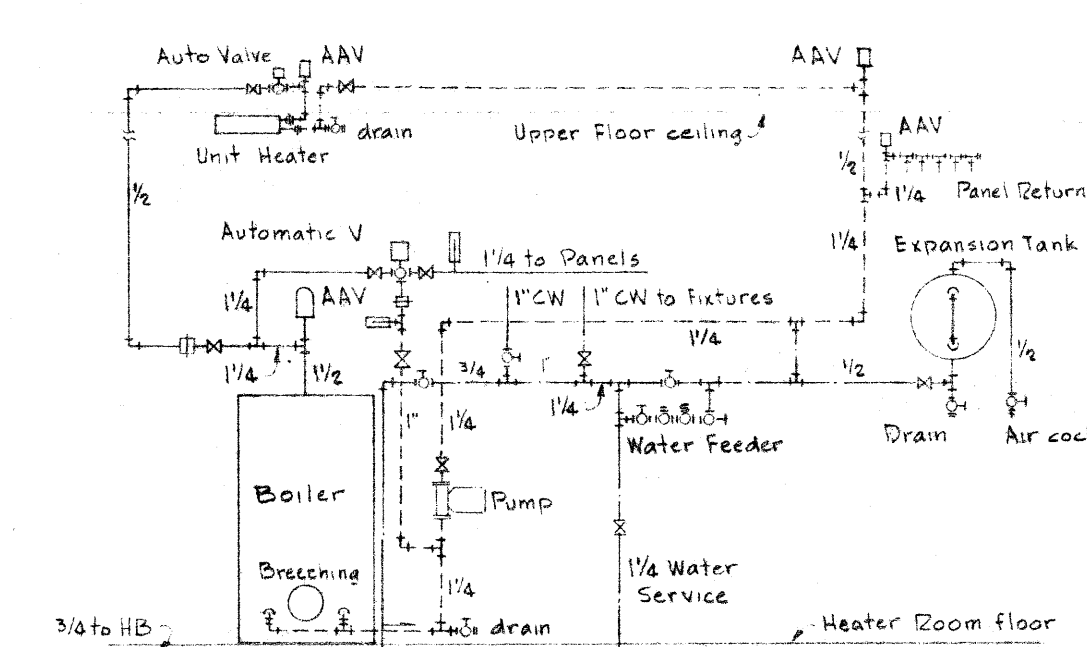
No Scale

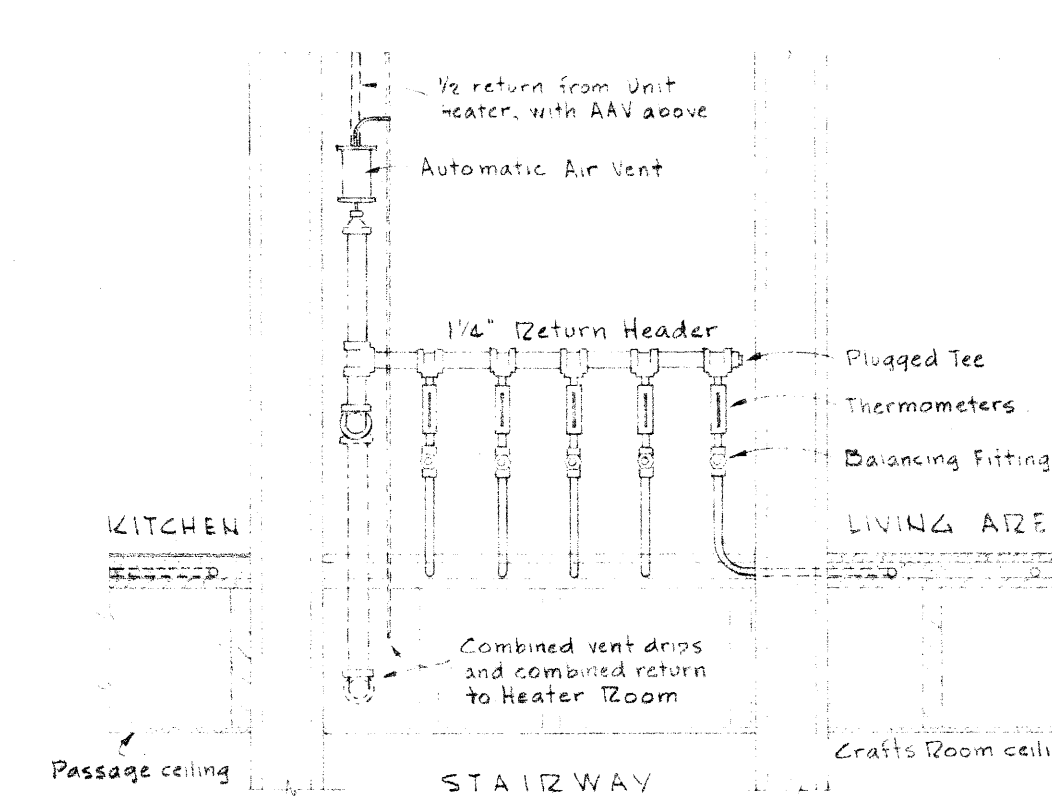

PANELS AND RETURN HEADERS
SECTION ELEVATION


$$\frac{3}{4}'' = 1'-0''$$


SECTION ELEVATION
SEPTIC TANK DETAILS

$$3/8'' = 1' - 0''$$


HEATING PIPING DIAGRAM

No Scale

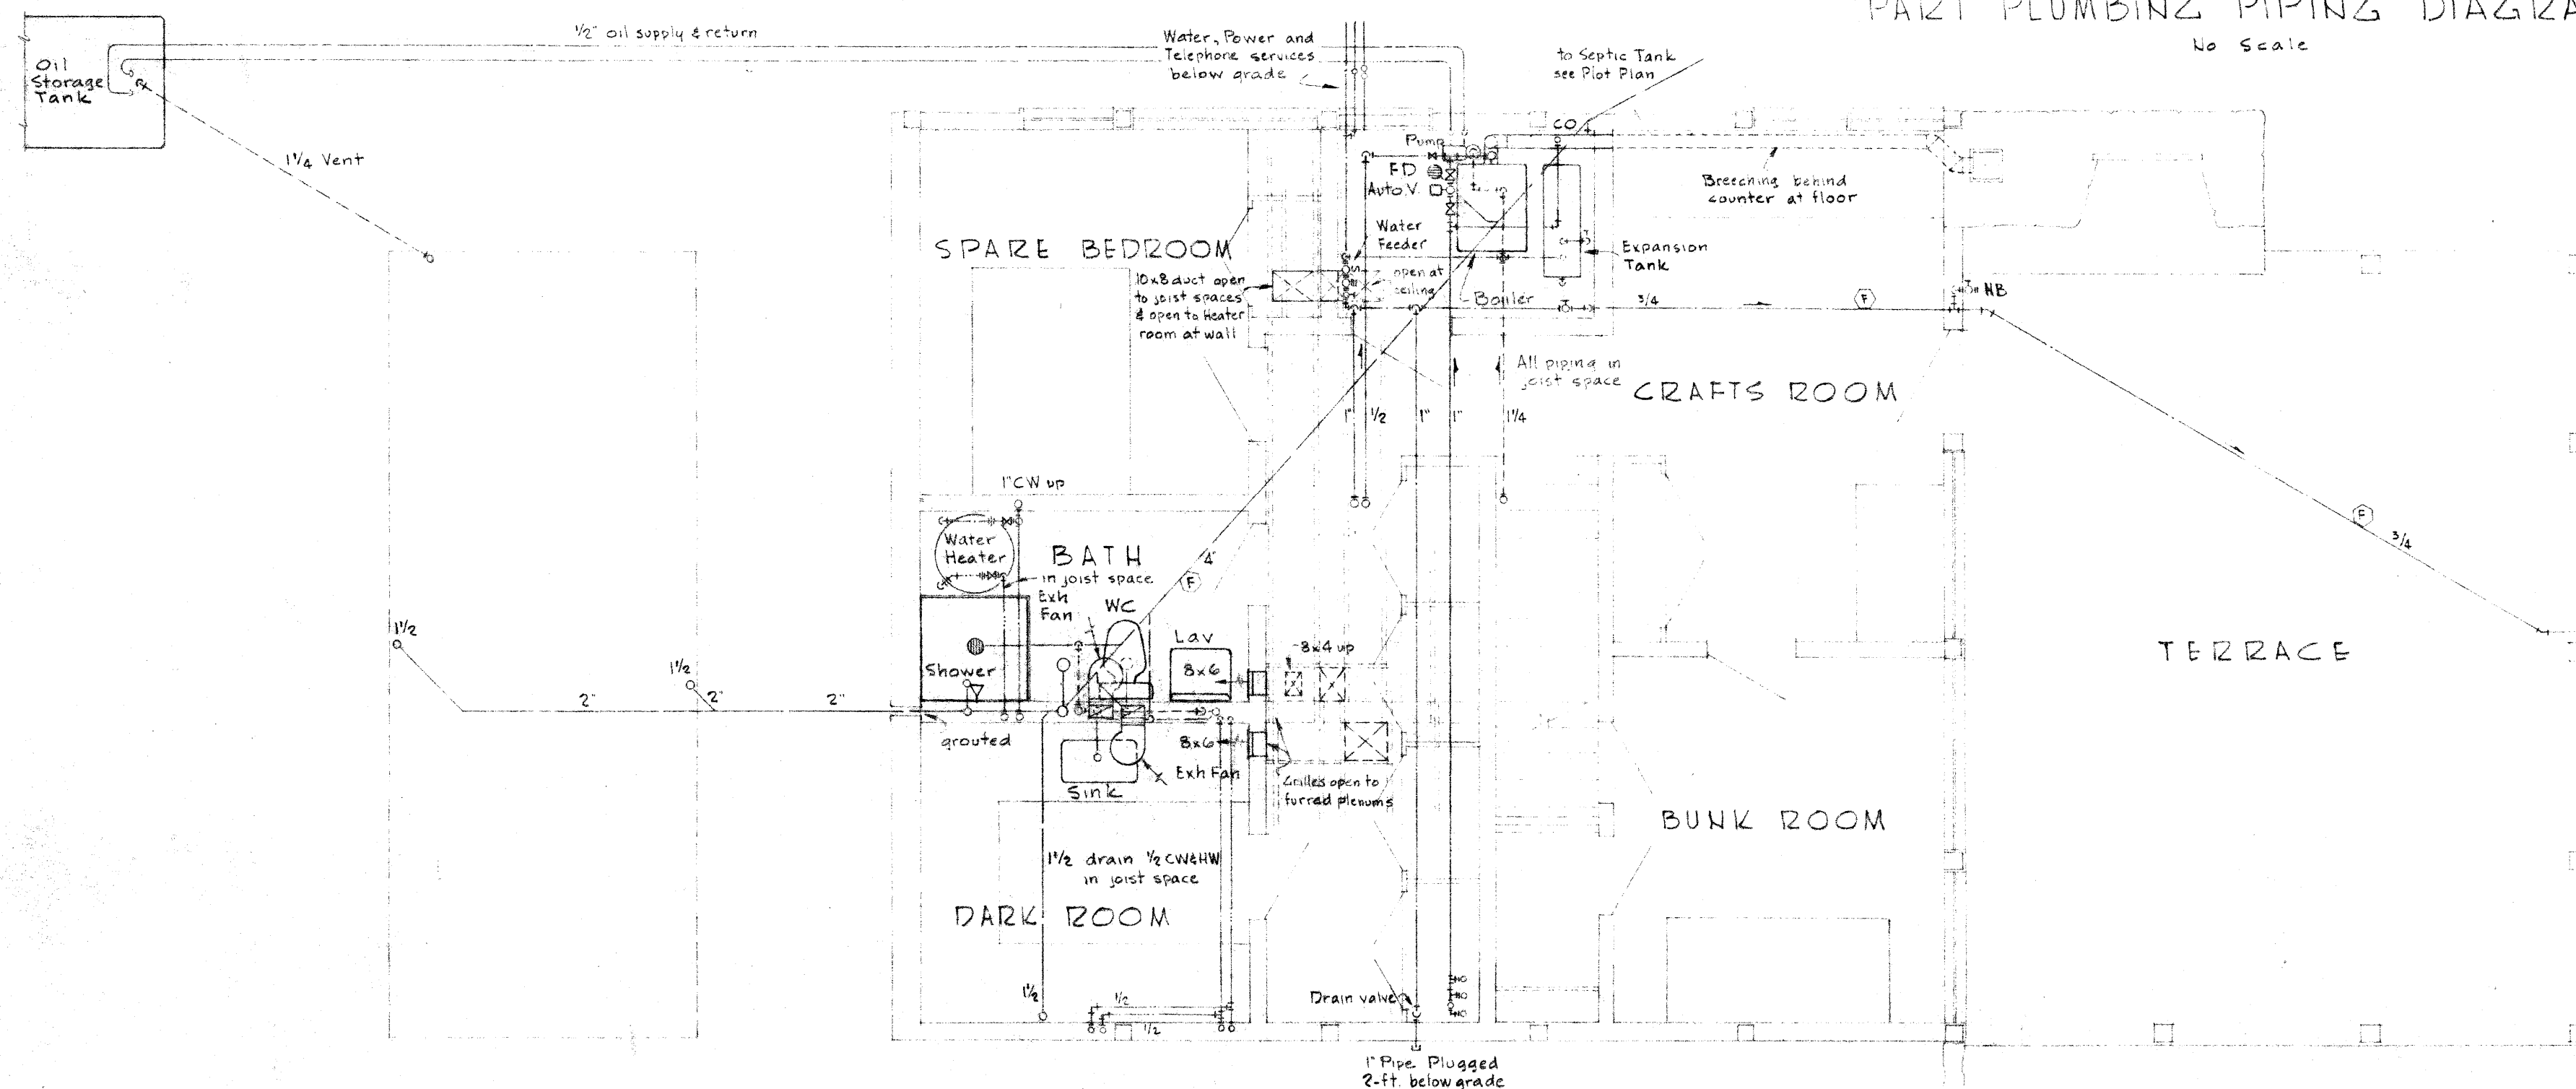

LOWER FLOOR PLAN

$$1/4" = 1'-0"$$

- SYMBOLS.

- | | | |
|--|------------|----------------------------------|
| | S | Heating supply piping |
| | R | Heating return piping |
| | | Globe valve |
| | | Automatic valve |
| | | Gate valve |
| | | Balancing Fitting |
| | | Union |
| | | Thermometer |
| | | Waste end drain valve |
| | AAV | Automatic air vent |
| | | Location for thermostat & switch |
| | | Duct section supply & exhaust |
| | | Wall supply grille |
| | CW | Cold water piping |
| | HW | Hot water piping |
| | | Waste, soil and drainage piping |
| | V | Vent piping |
| | | Piping below floor |
| | CO | Cleanout |
| | | Pressure reducing valve |
| | | Relief valve |
| | FD | Floor drain |
| | HB | Hose bibb |

- GENERAL NOTES.

1. Boiler burner unit, pump, water heater, exhaust fans; temperature control equipment, and all plumbing fixtures except floor drain are provided by others.
2. Temperature control equipment installed by others; installation of equipment shown, including those listed above, and making of final connections thereto are under the scope of this work.

MECHANICAL PLANS & DETAILS

MOUNTAIN HOUSE FOR
MR & MRS J DONALD KROEKER
MILWAUKIE HEIGHTS, OREGON

THE OFFICE OF
PIETRO BELLUSCHI - ARCHITECT
2040 S. W. JEFFERSON STREET - PORTLAND 1, OREGON

SCALE AS SHOWN	REVISIONS:	DATE Oct. 2, 1990
JOB NO. 216		DRAWING NO. M-1