



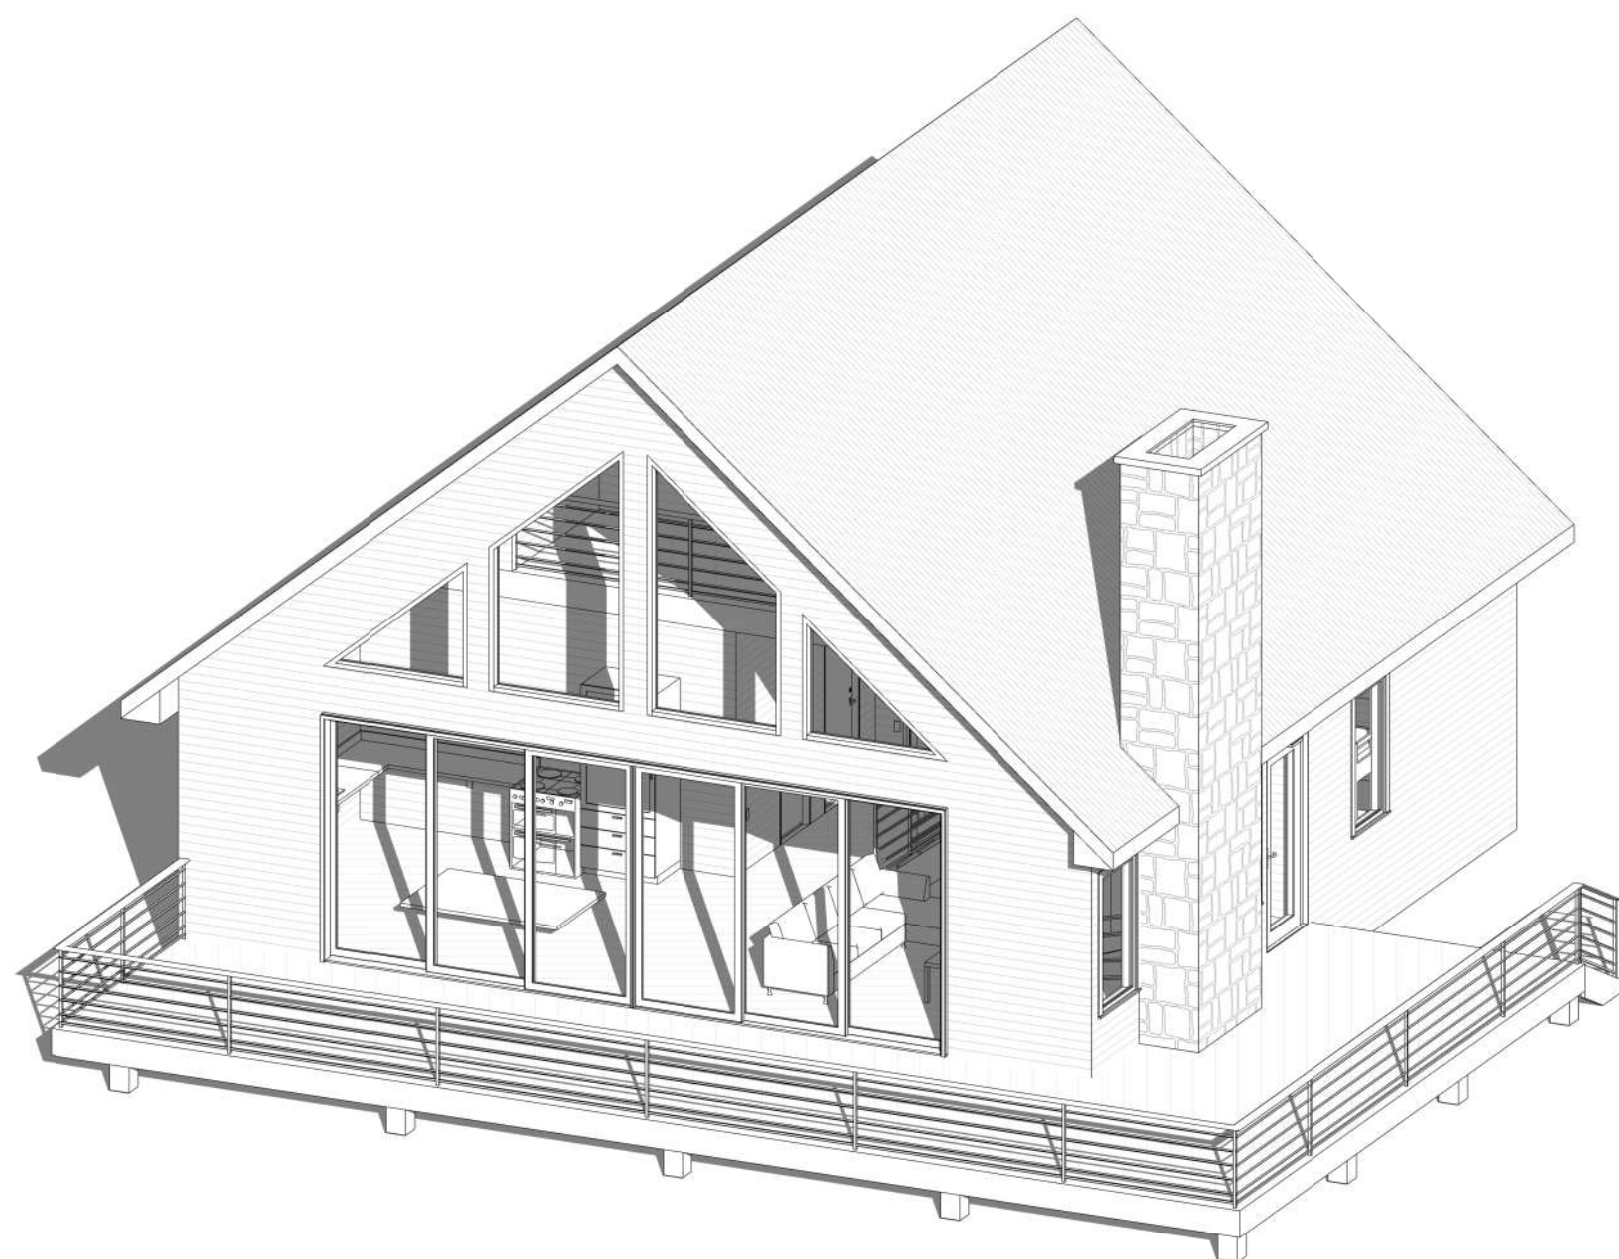

AXONOMETRIC VIEW

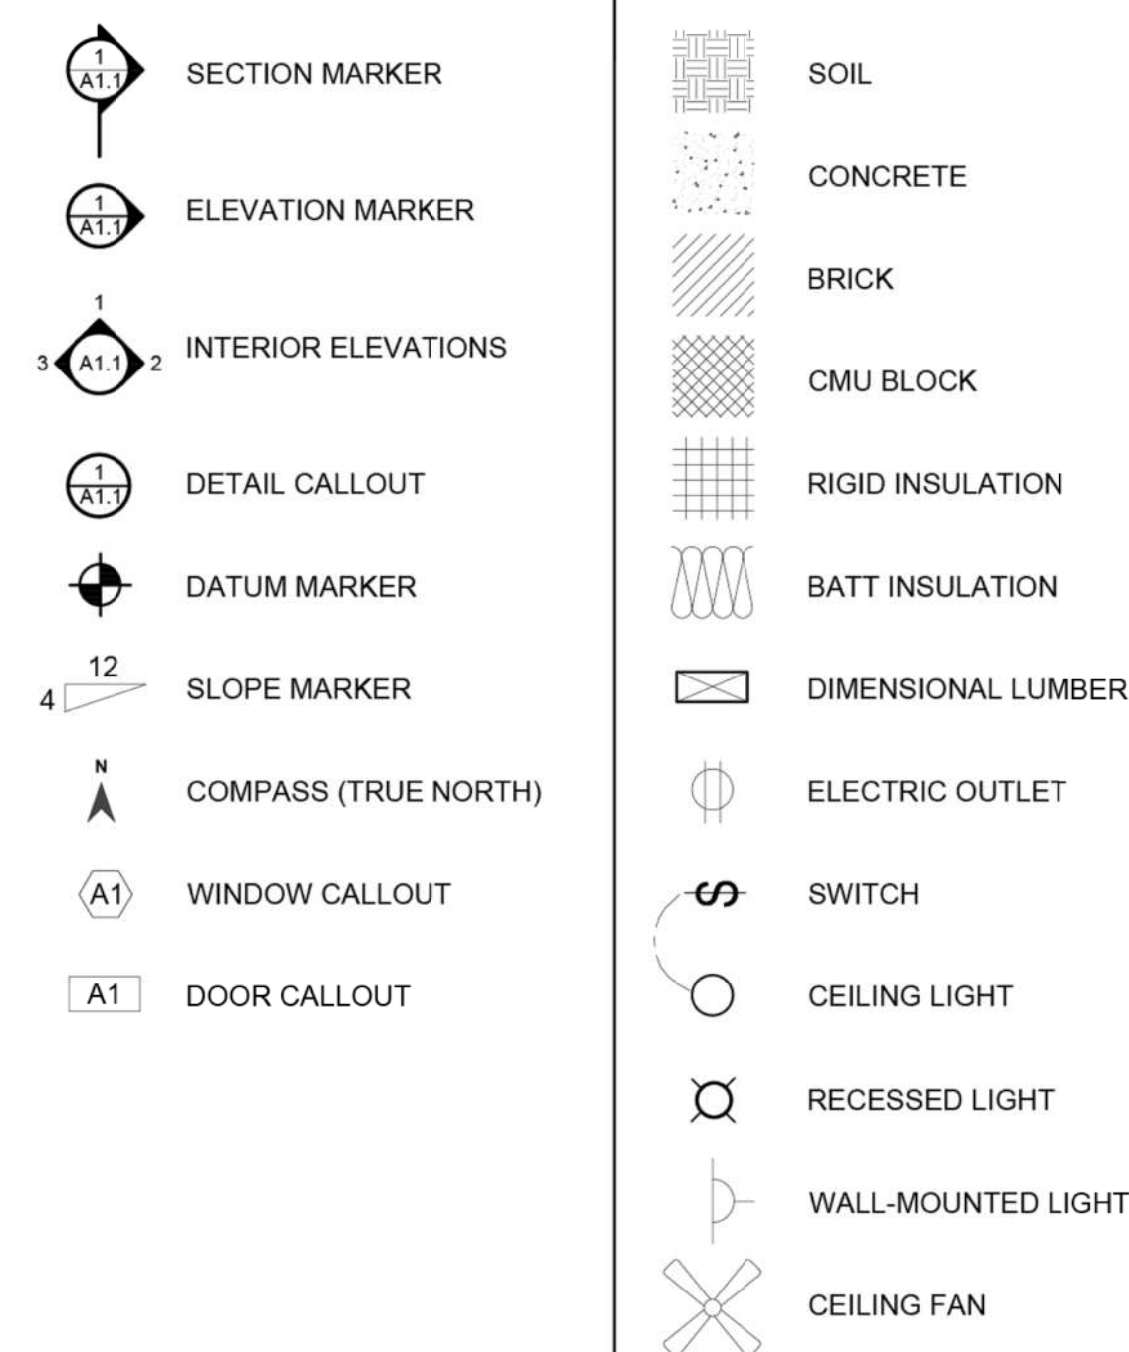

SYMBOLS LEGEND



SHEET INDEX

- A-000 COVER PAGE
- A-001 FIRST FLOOR PLAN
- A-002 SECOND FLOOR PLAN
- A-003 ELEVATION I
- A-004 ELEVATION II
- B-101 FOUNDATION PLAN
- B-102 FIRST FLOOR PLAN
- B-103 SECOND FLOOR PLAN
- B-104 DETAILED ELEVATIONS I
- B-105 DETAILED ELEVATIONS II
- B-106 ELECTRICAL PLANS
- B-107 ROOF PLAN
- B-108 ROOF FRAMING PLAN
- B-109 SECTION DETAIL
- B-110 DETAILS I
- B-111 DETAILS II
- B-112 STAIRCASE LAYOUT
- C-101 DOOR SCHEDULE
- C-102 WINDOW SCHEDULE

LICENSE & DISCLAIMER

1. THE WORK INCLUDED WITHIN THESE DRAWINGS DOES NOT REPRESENT A LEGAL CONTRACT; NOR DOES IT CONSTITUTE ARCHITECTURAL SERVICES. NO PERSON OR ORGANIZATION MAKES ANY WARRANTY, EXPRESS OR IMPLIED, REGARDING THE INFORMATION PROVIDED. THE CRATORS DISCLAIM LIABILITY FOR ANY DAMAGES THAT MAY RESULT FROM THE USE OF THESE DRAWINGS.

2. THIS PLAN HAS BEEN PREPARED TO MEET PROFESSIONAL STANDARDS AND PRACTICES. HOWEVER, BUILDING CODE REQUIREMENTS VARY WITH LOCATION AND CHANGE FROM TIME TO TIME. BEFORE STARTING CONSTRUCTION THE CONTRACTOR MUST REVIEW AND BE RESPONSIBLE FOR ALL DIMENSIONS AND OTHER DETAILS AND SHOULD REVIEW PLANS TO INSURE THEY MEET CURRENT REQUIREMENTS. THE CONTRACTOR ASSUMES FULL RESPONSIBILITY TO VERIFY THE CONDITIONS, DIMENSIONS, AND STRUCTURAL DETAILS OF THE BUILDING, AND ASSUMES FULL LIABILITY FOR ANY PROBLEMS THAT MAY ARISE DUE TO POSSIBLE ERRORS ON THESE PLANS. ALL FEDERAL, STATE AND LOCAL CODES, ORDINANCES, REGULATIONS, ETC., SHALL BE CONSIDERED AS PART OF SPECIFICATIONS FOR THIS BUILDING AND SHALL TAKE PRECEDENCE OVER ANYTHING SHOWN, DESCRIBED OR IMPLIED WHERE SAME ARE AT VARIANCE. USE OF THESE PLANS CONSTITUTES COMPLIANCE WITH THE ABOVE TERMS.

3. THESE PLANS ARE OWNED AND COPYRIGHTED BY BUILDBLUEPRINT AND ARE INTENDED FOR PERSONAL USE ONLY. COPYING OR DISTRIBUTING WITHOUT PERMISSION IS ILLEGAL AND CAN RESULT UP TO FINES OF \$100,000 BY COURT. THESE PLANS ARE NOT INTENDED FOR COMMERCIAL USE, AND CANNOT BE DISTRIBUTED FOR CAPITAL GAINS.

Cabin 6 - Proposed 3 BD/ 2 BA



Copyrighted @ BuildBlueprint

NOTES

1. DRAWINGS SHOULD BE PRINTED ON ANSI C SIZE PAPER TO ENSURE ACCURATE SCALE PRINTING

2. CONSTRUCTION DETAILS ILLUSTRATED IN THIS SET ARE TYPICAL, CONSULT WITH YOUR BUILDER FOR DETAILS THAT MEETS YOUR LOCAL BUILDING CODE.

3. MATERIALS AND FINISHES ILLUSTRATED IN THIS SET ARE TYPICAL, AND SHOULD BE VERIFIED BY YOUR BUILDER OR DESIGNER BEFORE CONSTRUCTION.

4. THIS DRAWING SET IS NOT INTENDED FOR PERMITTING OR CONSTRUCTION. CONSULT WITH YOUR LOCAL BUILDING DEPARTMENT FOR BUILDING CODE REQUIREMENTS.

[illegible]

LONG CREEK CABIN
(MIRRORED)

COVER PAGE


Project number	BB-HP0013
Date	09/2021
Drawn by	B.B
Checked by	J.L

A-000

Sheet Number	A-000
Scale	



AXONOMETRIC VIEW

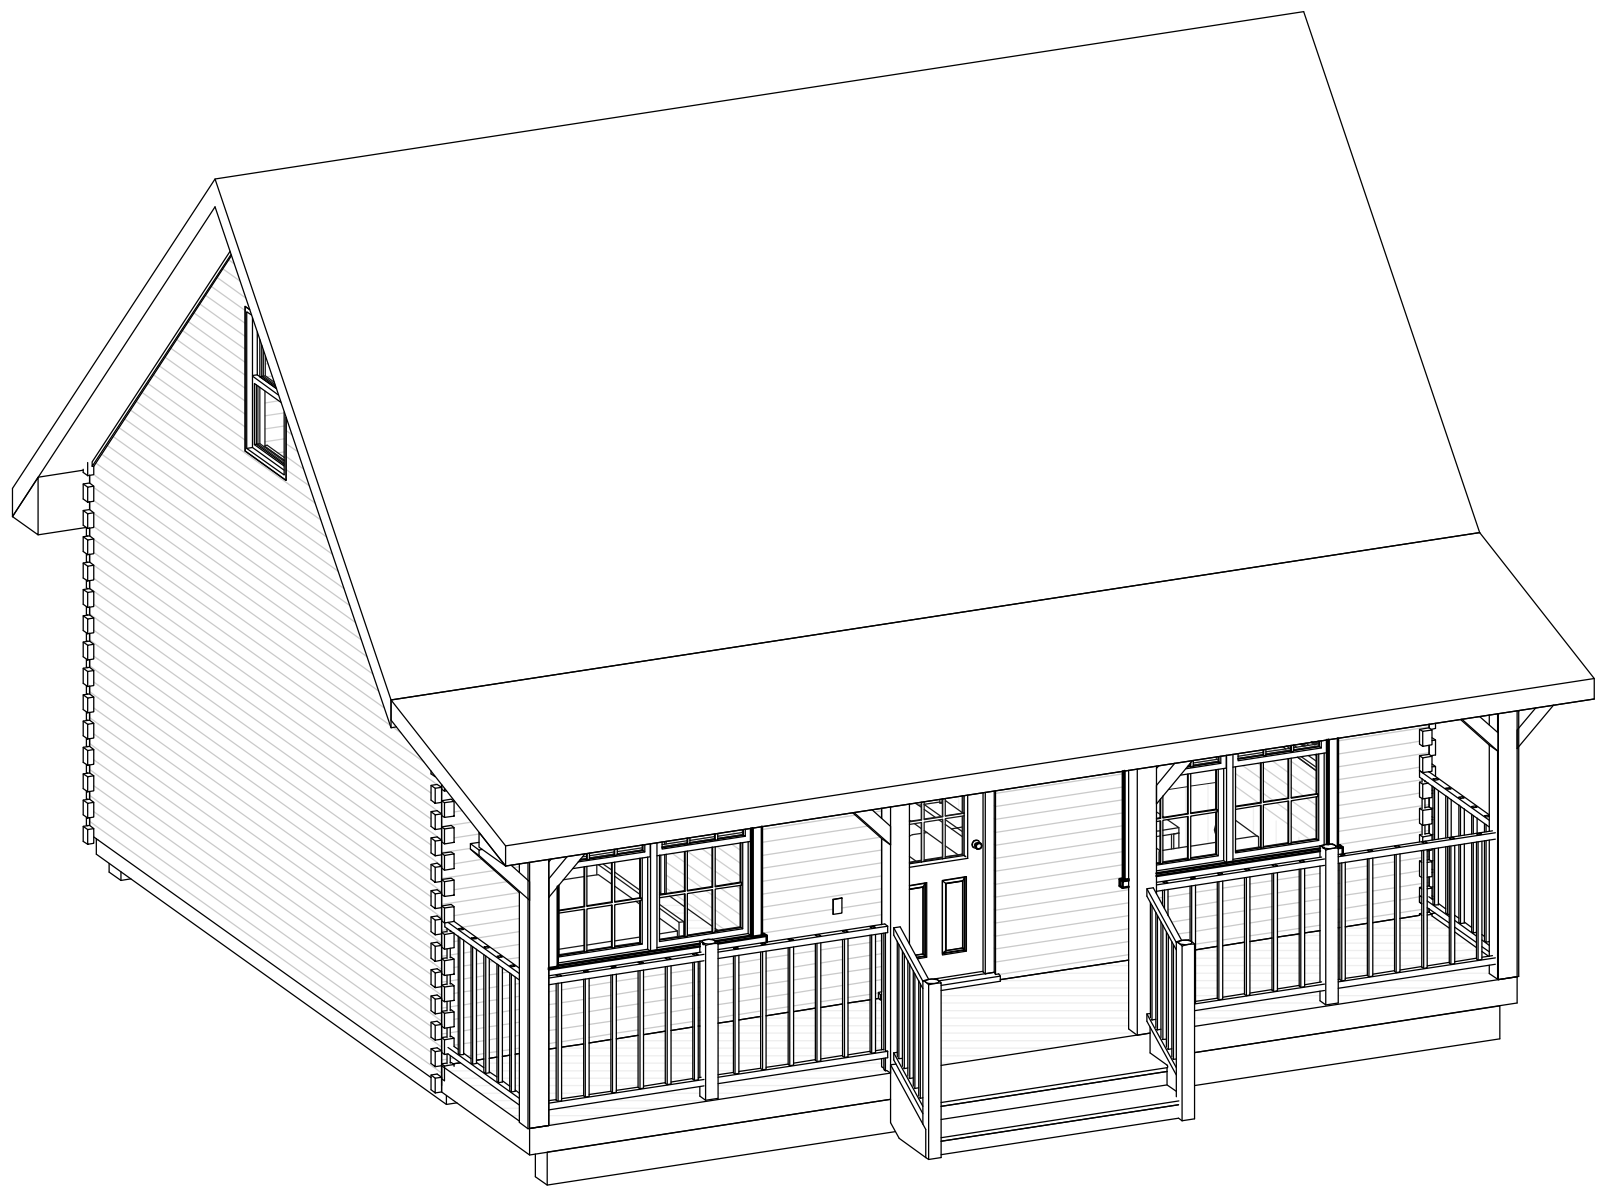

SYMBOLS LEGEND

- SECTION MARKER
- ELEVATION MARKER
- INTERIOR ELEVATIONS
- DETAIL CALLOUT
- DATUM MARKER
- SLOPE MARKER
- COMPASS (TRUE NORTH)
- WINDOW CALLOUT
- DOOR CALLOUT
- SOIL
- CONCRETE
- BRICK
- CMU BLOCK
- RIGID INSULATION
- BATT INSULATION
- DIMENSIONAL LUMBER
- ELECTRIC OUTLET
- SWITCH
- CEILING LIGHT
- RECESSED LIGHT
- WALL-MOUNTED LIGHT
- CEILING FAN

SHEET INDEX

- A-000 COVER PAGE
- A-001 FIRST FLOOR PLAN
- A-002 SECOND FLOOR PLAN
- A-003 ELEVATION I
- A-004 ELEVATION II
- B-101 FOUNDATION PLAN
- B-102 FIRST FLOOR PLAN
- B-103 SECOND FLOOR PLAN
- B-104 DETAILED ELEVATIONS I
- B-105 DETAILED ELEVATIONS II
- B-106 ELECTRICAL PLAN
- B-107 ROOF PLAN
- B-108 ROOF FRAMING PLAN
- B-109 SECTION DETAIL
- B-110 DETAILS I
- B-111 DETAILS II
- C-101 DOOR SCHEDULE
- C-102 WINDOW SCHEDULE

LICENSE & DISCLAIMER

1. THE WORK INCLUDED WITHIN THESE DRAWINGS DOES NOT REPRESENT A LEGAL CONTRACT; NOR DOES IT CONSTITUTE ARCHITECTURAL SERVICES. NO PERSON OR ORGANIZATION MAKES ANY WARRANTY, EXPRESS OR IMPLIED, REGARDING THE INFORMATION PROVIDED. THE CRATORS DISCLAIM LIABILITY FOR ANY DAMAGES THAT MAY RESULT FROM THE USE OF THESE DRAWINGS.
2. THIS PLAN HAS BEEN PREPARED TO MEET PROFESSIONAL STANDARDS AND PRACTICES. HOWEVER, BUILDING CODE REQUIREMENTS VERY WITH LOCATION AND CHANGE FROM TIME TO TIME. BEFORE STARTING CONSTRUCTION THE CONTRACTOR MUST REVIEW AND BE RESPONSIBLE FOR ALL DIMENSIONS AND OTHER DETAILS AND SHOULD REVIEW PLANS TO INSURE THEY MEET CURRENT REQUIREMENTS. THE CONTRACTOR ASSUMES FULL RESPONSIBILITY TO VERIFY THE CONDITIONS, DIMENSIONS, AND STRUCTURAL DETAILS OF THE BUILDING, AND ASSUMES FULL LIABILITY FOR ANY PROBLEMS THAT MAY ARISE DUE TO POSSIBLE ERRORS ON THESE PLANS. ALL FEDERAL, STATE AND LOCAL CODES, ORDINANCES, REGULATIONS, ETC.,SHALL BE CONSIDERED AS PART OF SPECIFICATIONS FOR THIS BUILDING AND SHALL TAKE PRECEDENCE OVER ANYTHING SHOWN, DESCRIBED OR IMPLIED WHERE SAME ARE AT VARIANCE. USE OF THESE PLANS CONSTITUTES COMPLIANCE WITH THE ABOVE TERMS.
3. THESE PLANS ARE OWNED AND COPYRIGHTED BY BUILDBLUEPRINT AND ARE INTENTED FOR PERSONAL USE ONLY. COPYING OR DISTRIBUTING WITHOUT PERMISSION IS ILLEGAL AND CAN RESULT UP TO FINES OF \$100,000 BY COURT. THESE PLANS ARE NOT INTENDED FOR COMMERCIAL USE, AND CANNOT BE DISTRIBUTED FOR CAPITAL GAINS.

Cabin 5 - Proposed
2 BD/ 1 BA

NOTES

1. DRAWINGS SHOULD BE PRINTED ON ANSI C SIZE PAPER TO ENSURE ACCURATE SCALE PRINTING
2. CONSTRUCTION DETAILS ILLUSTRATED IN THIS SET ARE TYPICAL, CONSULT WITH YOUR BUILDER FOR DETAILS THAT MEETS YOUR LOCAL BUILDING CODE.
3. MATERIALS AND FINISHES ILLUSTRATED IN THIS SET ARE TYPICAL, AND SHOULD BE VERIFIED BY YOUR BUILDER OR DESIGNER BEFORE CONSTRUCTION.
4. THIS DRAWING SET IS NOT INTENDED FOR PERMITTING OR CONSTRUCTION. CONSULT WITH YOUR LOCAL BUILDING DEPARTMENT FOR BUILDING CODE REQUIREMENTS.

No.	Description	Date

ADIRONDACK CABIN

COVER PAGE



Project number	BB-HP0023
Date	
Drawn by	B.B
Checked by	J.L
	A-000
Sheet Number	A-000
Scale	

ANSI D (22" x 34")

Project Overview

Cabin 2 - Proposed
2 BD/ 2 BA

PLAN INDEX	
PAGE	PAGE TITLE
1	Project Overview
2	General Notes, Code Info, Symbols, Keys
3	Exterior Elevations
4	Architectural Plan, Floor 1
5	Architectural Plan, Floor 2
6	Foundation Plan, Details
7	Framing Plans, Floor 1
8	Framing Plans, Floor 2
9	Framing Cross Section Details
10	Framing Cross Section Details
11	Roof Layout Plan
12	Kitchen and Bath Plan NCMA

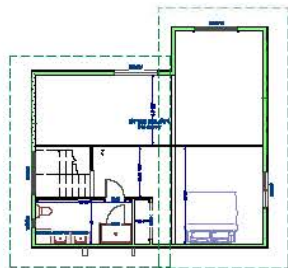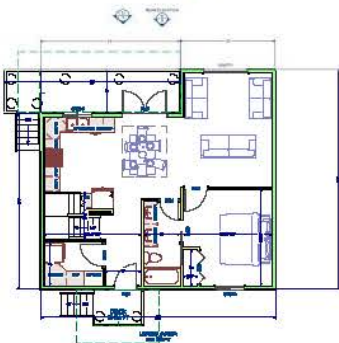

NOTE:
IF THIS PLAN IS PRINTED
ON 11"x17" PAPER, REDUCE
NOTED SCALE BY 50%

REVISIONS				
Number	Date	Revised By	Revised	Description

3D VIEWS ARE NOT TO
SCALE AND MAY NOT
REPRESENT EXACTLY WHAT
IS SHOWN IN THE PLAN
PROJECTS. RENDERING VIEW
AND PHOTOGRAPHY SHALL
BE USED TO VERIFY THE VIEW
SHOWN IN THE PLAN. THE
RENDERING SHALL NOT BE
USED TO SCALE. THE
RENDERING SHALL NOT BE
USED TO SCALE.

DELICATE BALANCE
RESIDENTIAL DESIGN &
DRAFTING
NINA BURKHOLDER
nina@delicatebalance.com 807-480-0000 or 807-480-0008

LICENSE NUMBER
1078679

NEW HOME PLANS FOR
MICHELE WHITON
CABIN 2 B
CLIENT EMAIL: . . .
PHONE: . . . CELL PHONE: . . .

PAGE TITLE:
Project Overview

DATE:
5/9/2022

SCALE:
1/4" = 10'

SHEET #:
1



© ALL RIGHTS RESERVED. REPRODUCTION AND DISTRIBUTION OF THIS PLAN WITHOUT WRITTEN PERMISSION IS PROHIBITED.

ANSI D (22" x 34")


Project Overview

Cabin 3 - Built
1 BD/ 2 BA

PLAN INDEX	
PAGE	PAGE TITLE
1	Project Overview
2	General Notes, Code Info, Symbols, Keys
3	Exterior Elevations
4	Exterior Elevations
5	Architectural Plan, Floor 1
6	Foundation Plan Details
7	Framing Plans Floor 1
8	Framing Cross Section Details
9	Roof Layout Plan
10	Kitchen and Bath Plan NKBA

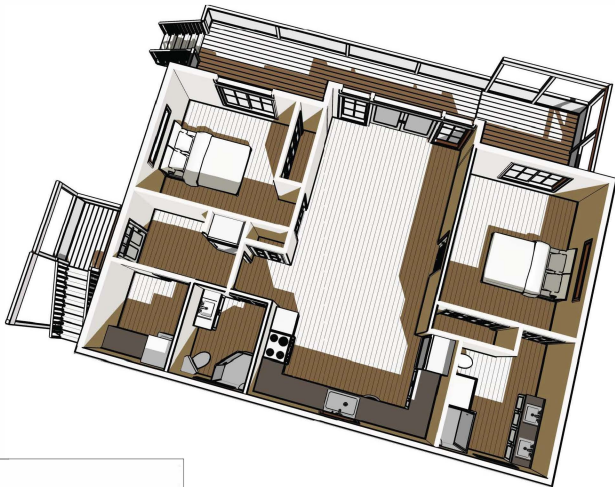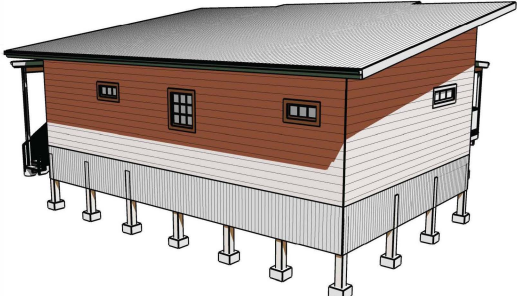

NOTE:
IF THIS PLAN IS PRINTED
ON 11"x17" PAPER, REDUCE
NOTED SCALE BY 50%

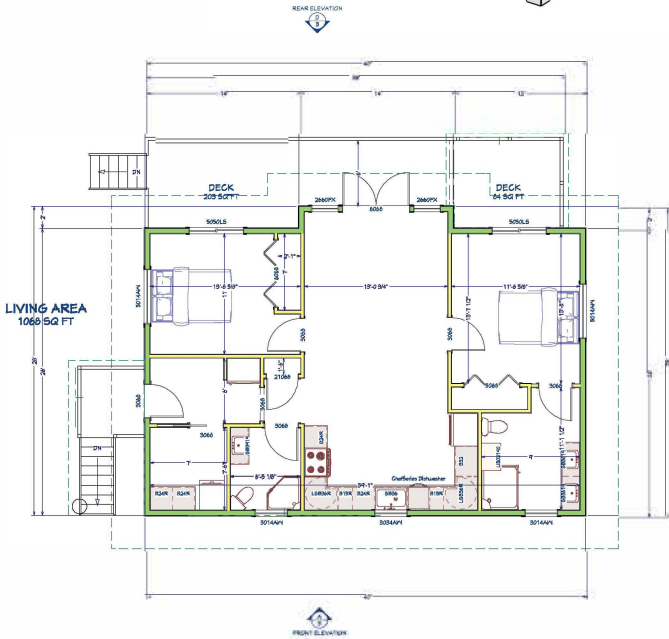

3D VIEWS ARE NOT TO
SCALE AND MAY NOT
REPRESENT EXACTLY WHAT
IS AVAILABLE FOR THE
PROJECT. RENDER VIEWS
ARE REPRESENTATIONS
OF WHAT THE VIEW
COULD LOOK LIKE, NOT
WHAT IT WILL LOOK LIKE.
3D VIEWS ALWAYS
SUPERSEDE 2D VIEWS

DELICATE BALANCE
RESIDENTIAL DESIGN &
DRAFTING
NINA BURKHOLDER
nina@delicatebalance.com 907-235-2831 or 907-869-0226

LICENSE NUMBER:
1078679

NEW HOME PLANS FOR:
MICHELE WHITON
CABIN #3
CLIENT EMAIL:
PHONE:
CELL PHONE:

PAGE TITLE:
Project Overview

DATE:
5/10/2022

SCALE:
1/4" = 1'0"

SHEET #:
1

© ALL RIGHTS RESERVED. DUPLICATION AND DISTRIBUTION OF THIS PLAN WITHOUT WRITTEN PERMISSION IS PROHIBITED.