



MUSTANG CHASE

12100 Mustang Chase, Austin, TX

78727

MJE HOLDINGS
LLC


FLOOR PLAN

Date 9/19/2025
Drawn By ANNA ORLOWSKI

A101

Scale 3/8" = 1'-0"

9/27/2025 3:30:25 PM

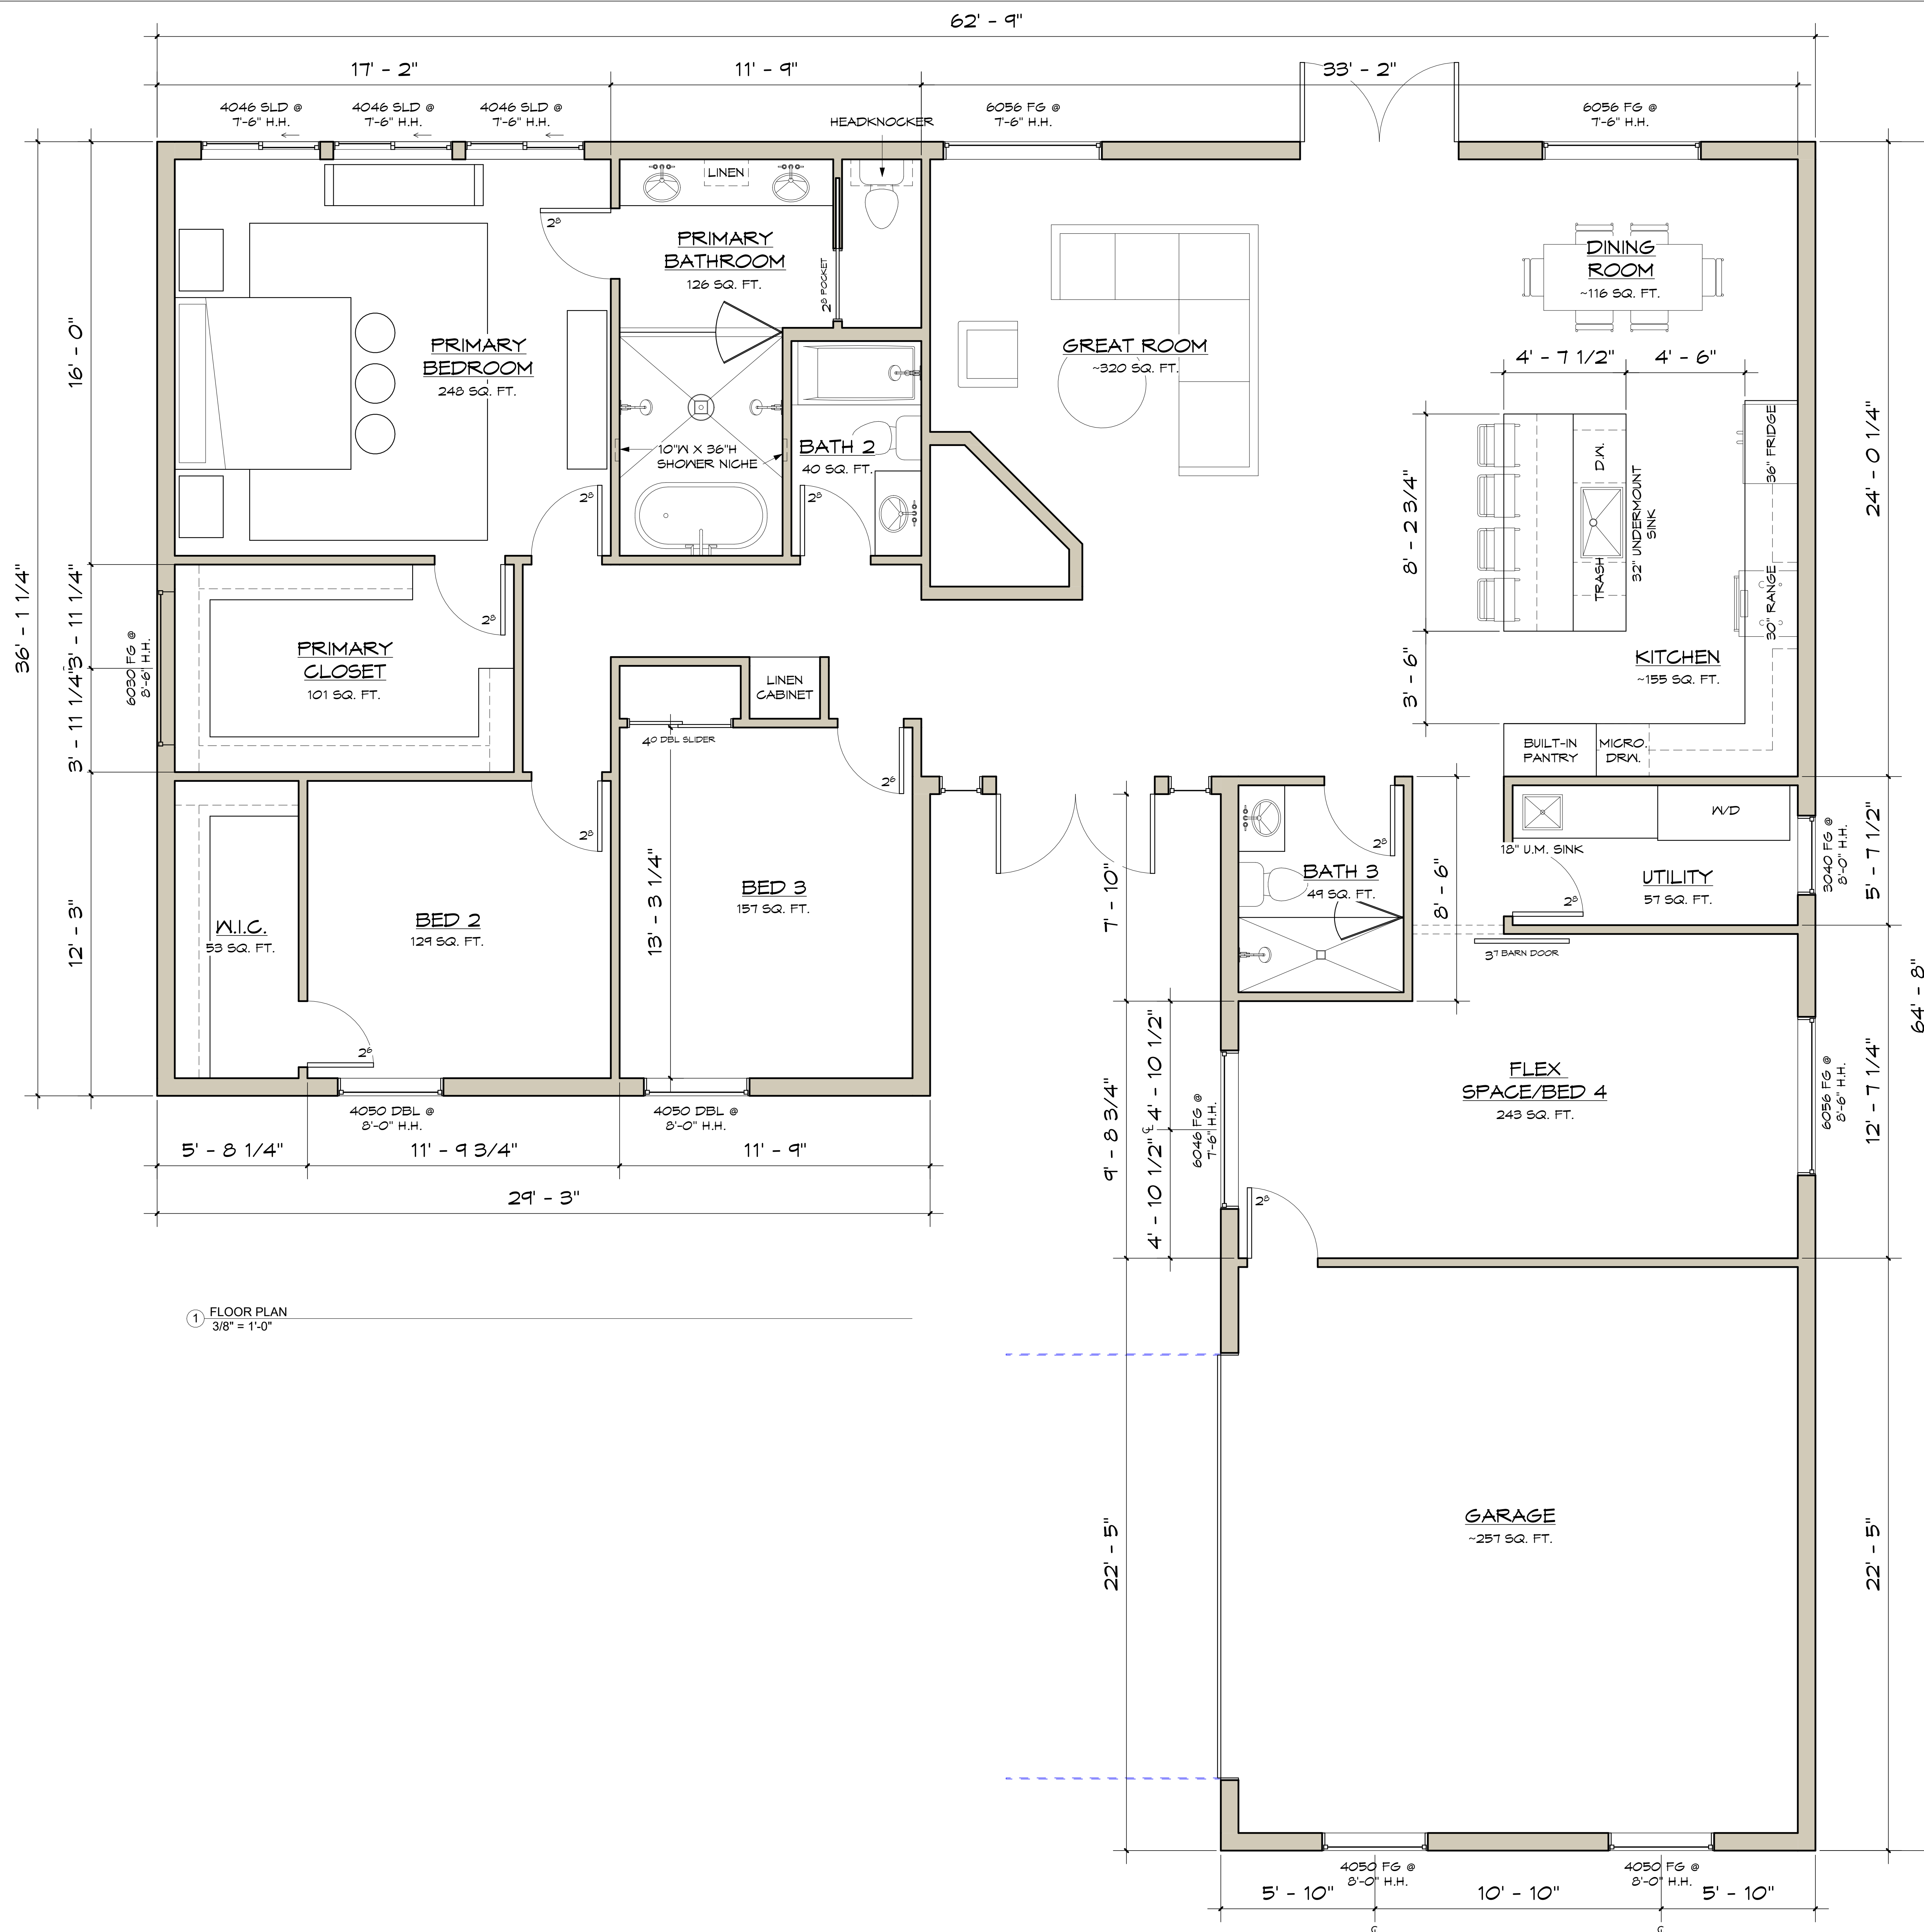



MUSTANG CHASE

12100 Mustang Chase, Austin, TX

78727

MJE HOLDINGS
LLC


REFLECTED
CEILING PLAN

Date 9/19/2025

Drawn By Author

A102

Scale As indicated

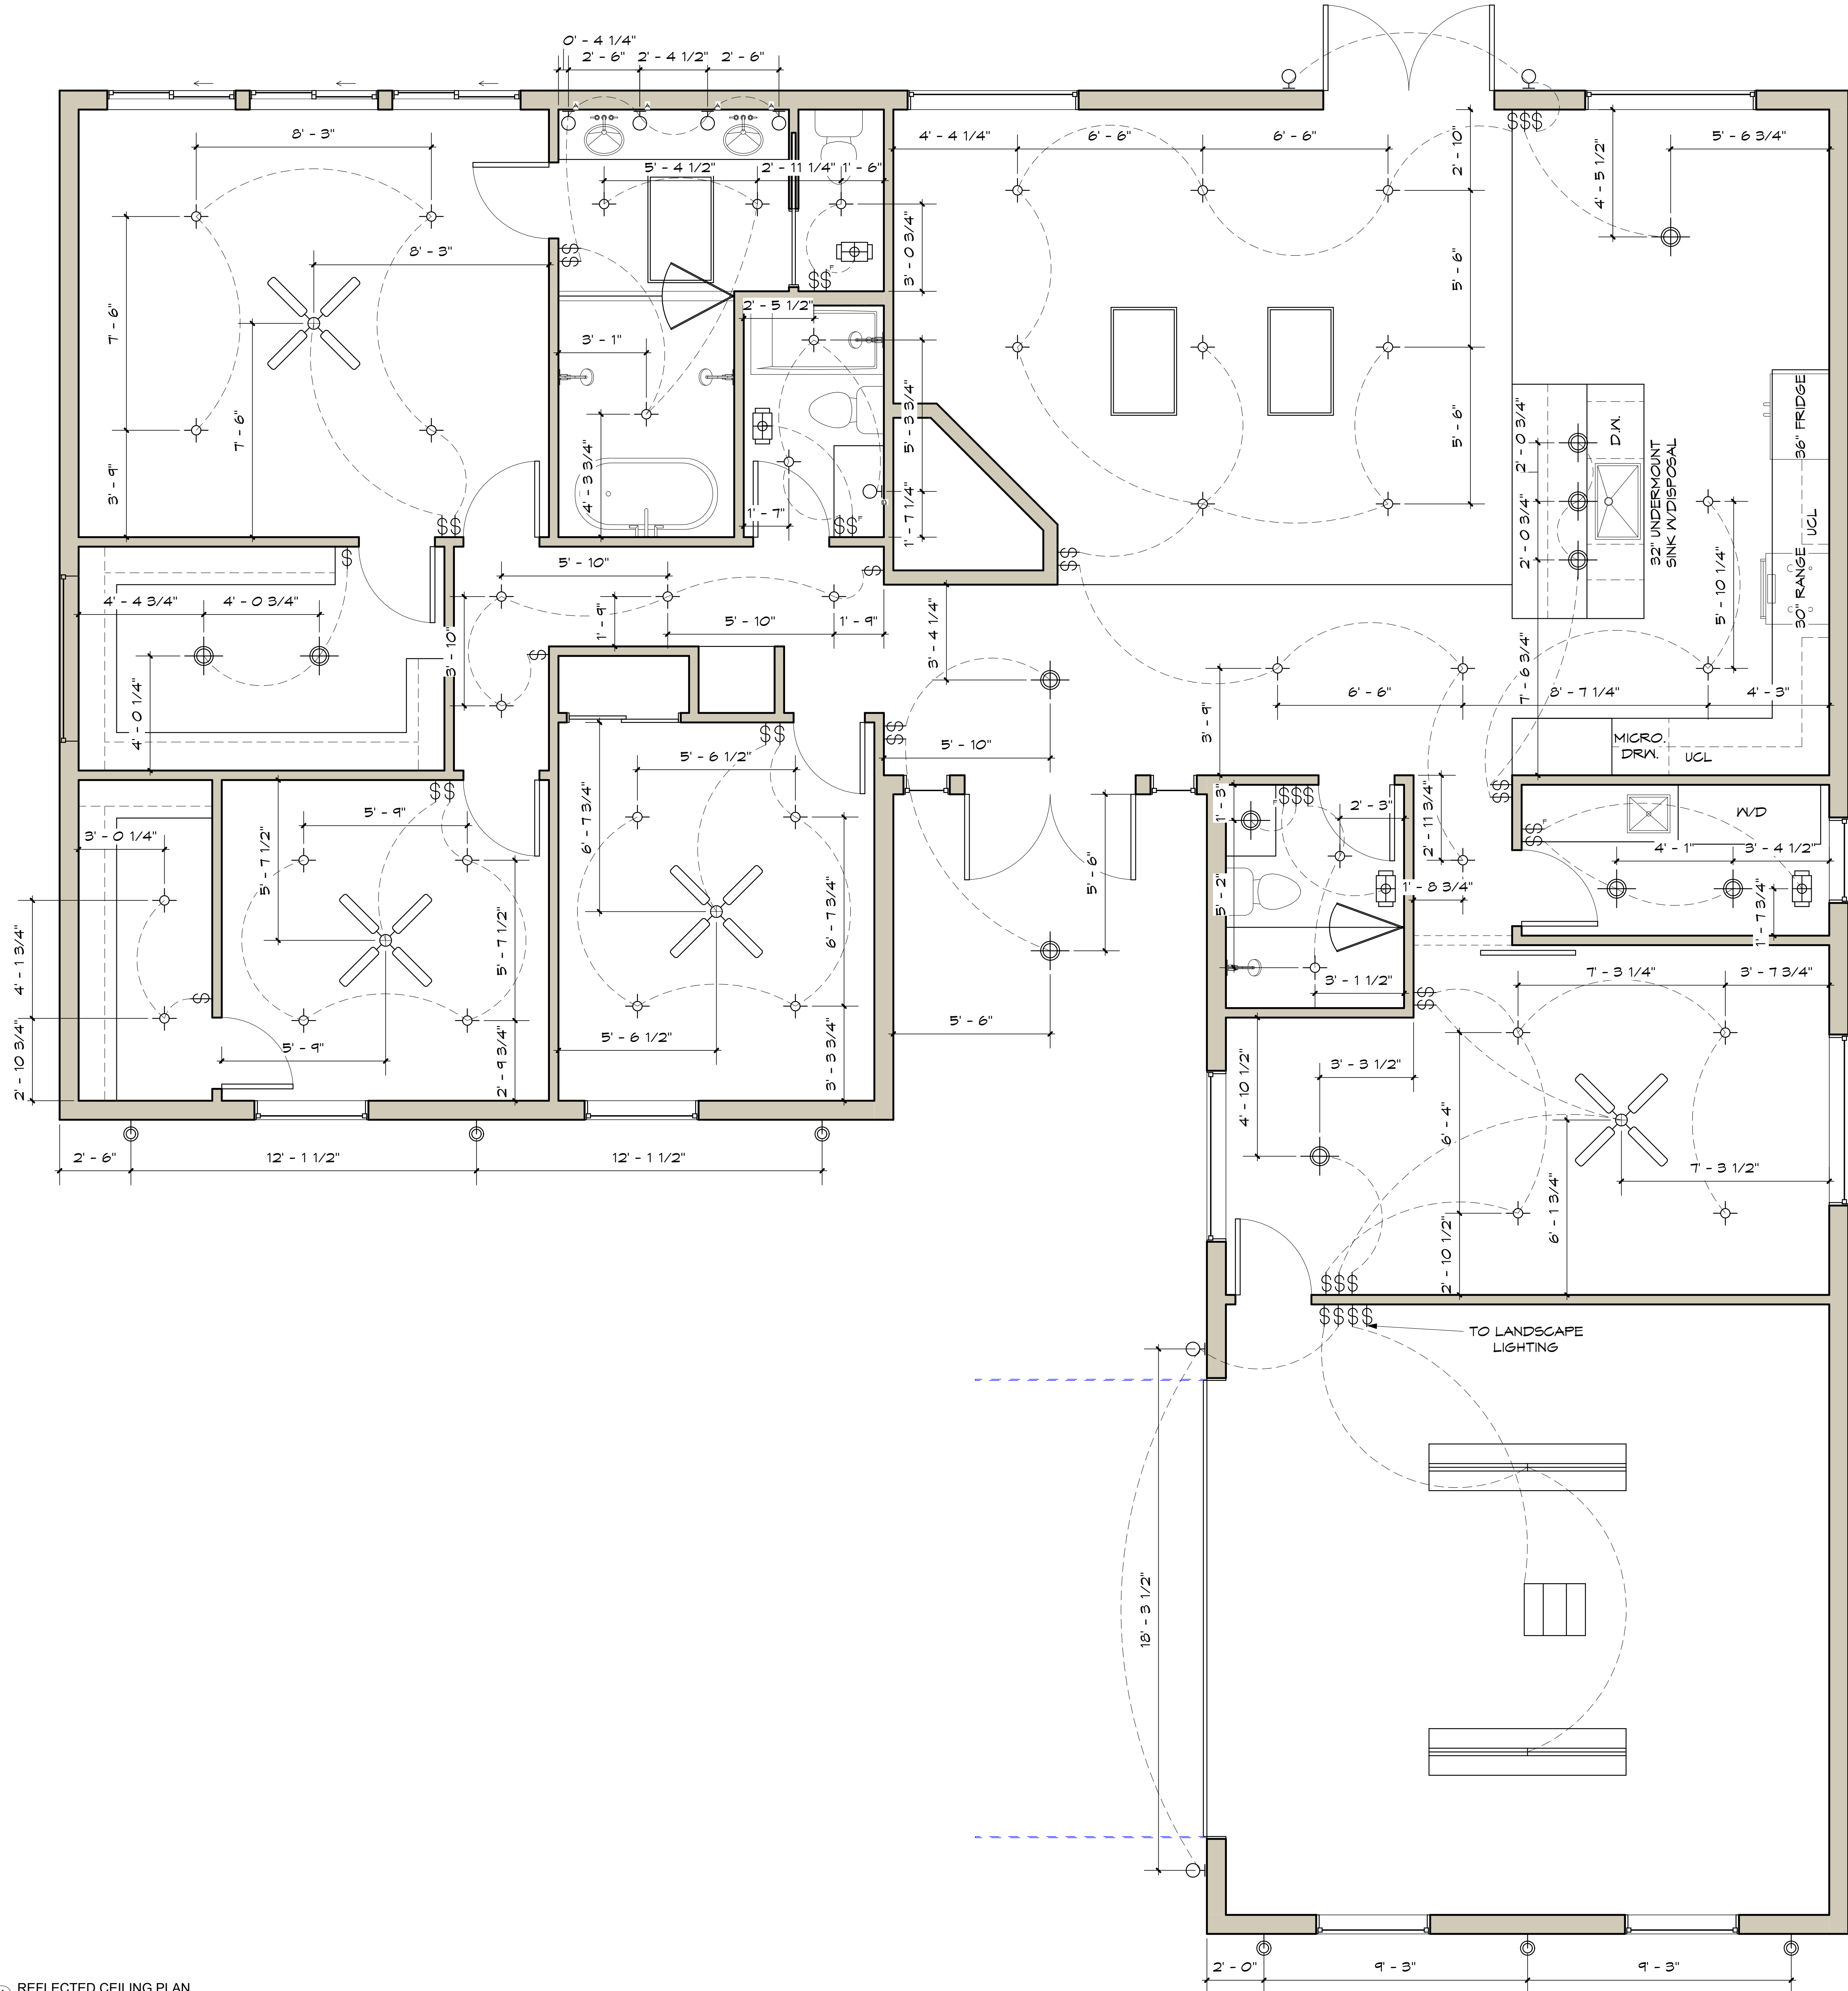

LIGHTING INDEX	
	52" FAN WITH LIGHT KIT
	DECORATIVE HANGING/FLUSHMOUNT LIGHT FIXTURE
A	WALL SCONCE SET AT 64" AFF
B	WALL SCONCE SET AT 98" AFF & CENTERED ON VANITY
	4" RECESSED CAN
\$	SWITCH
\$ F	SWITCH TO VENT FAN
	OUTLET PLUG
UCL	LED TAPE LIGHT
	EXTERIOR UP LIGHT

② Lighting Index 1/2" = 1'-0"

① REFLECTED CEILING PLAN 3/8" = 1'-0"